




SOUNDSIDE SEPTIC TANK ELIMINATION PROGRAM - PHASE B

CITY OF GULF BREEZE
SANTA ROSA COUNTY, FLORIDA

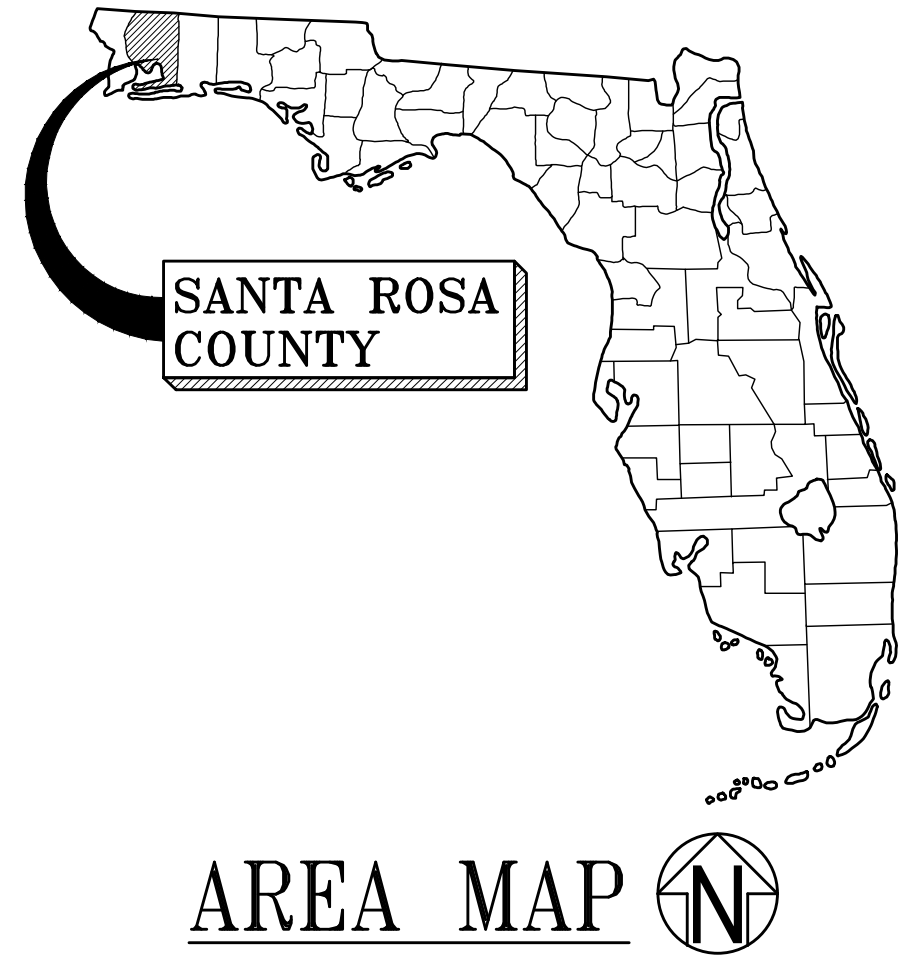

BDI Project No. 20410.46
FEBRUARY 2022


PREPARED BY

BASKERVILLE-DONOVAN, INC.
Innovative Infrastructure Solutions

449 W. MAIN ST., PENSACOLA, FL 32502 (850)438-9661
ENGINEERING BUSINESS: EB-0000340

SHEET INDEX

G-000	COVER
G-001	GENERAL NOTES AND ABBREVIATIONS
C-001	CIVIL LEGEND
C-100	SANITARY SEWER ROUTE KEY SHEET
C-101	SANITARY SEWER ROUTE PLAN - SOUNDSIDE DRIVE
C-102	SANITARY SEWER ROUTE PLAN - SOUNDSIDE DRIVE
C-103	SANITARY SEWER ROUTE PLAN - SOUNDSIDE DRIVE
C-104	SANITARY SEWER ROUTE PLAN - SOUNDSIDE DRIVE
C-105	SANITARY SEWER ROUTE PLAN - SOUNDSIDE DRIVE
C-106	SANITARY SEWER ROUTE PLAN - SPRUCE STREET
C-107	SANITARY SEWER ROUTE PLAN - SPRUCE STREET
C-108	SANITARY SEWER ROUTE PLAN - SPRUCE STREET
C-200	DIRECTIONAL DRILL DETAIL AND SCHEDULE
C-900	STANDARD DETAILS
C-901	STANDARD DETAILS
C-902	STANDARD DETAILS
C-903	STANDARD DETAILS
C-904	STANDARD DETAILS
C-905	MAINTENANCE OF TRAFFIC DETAILS

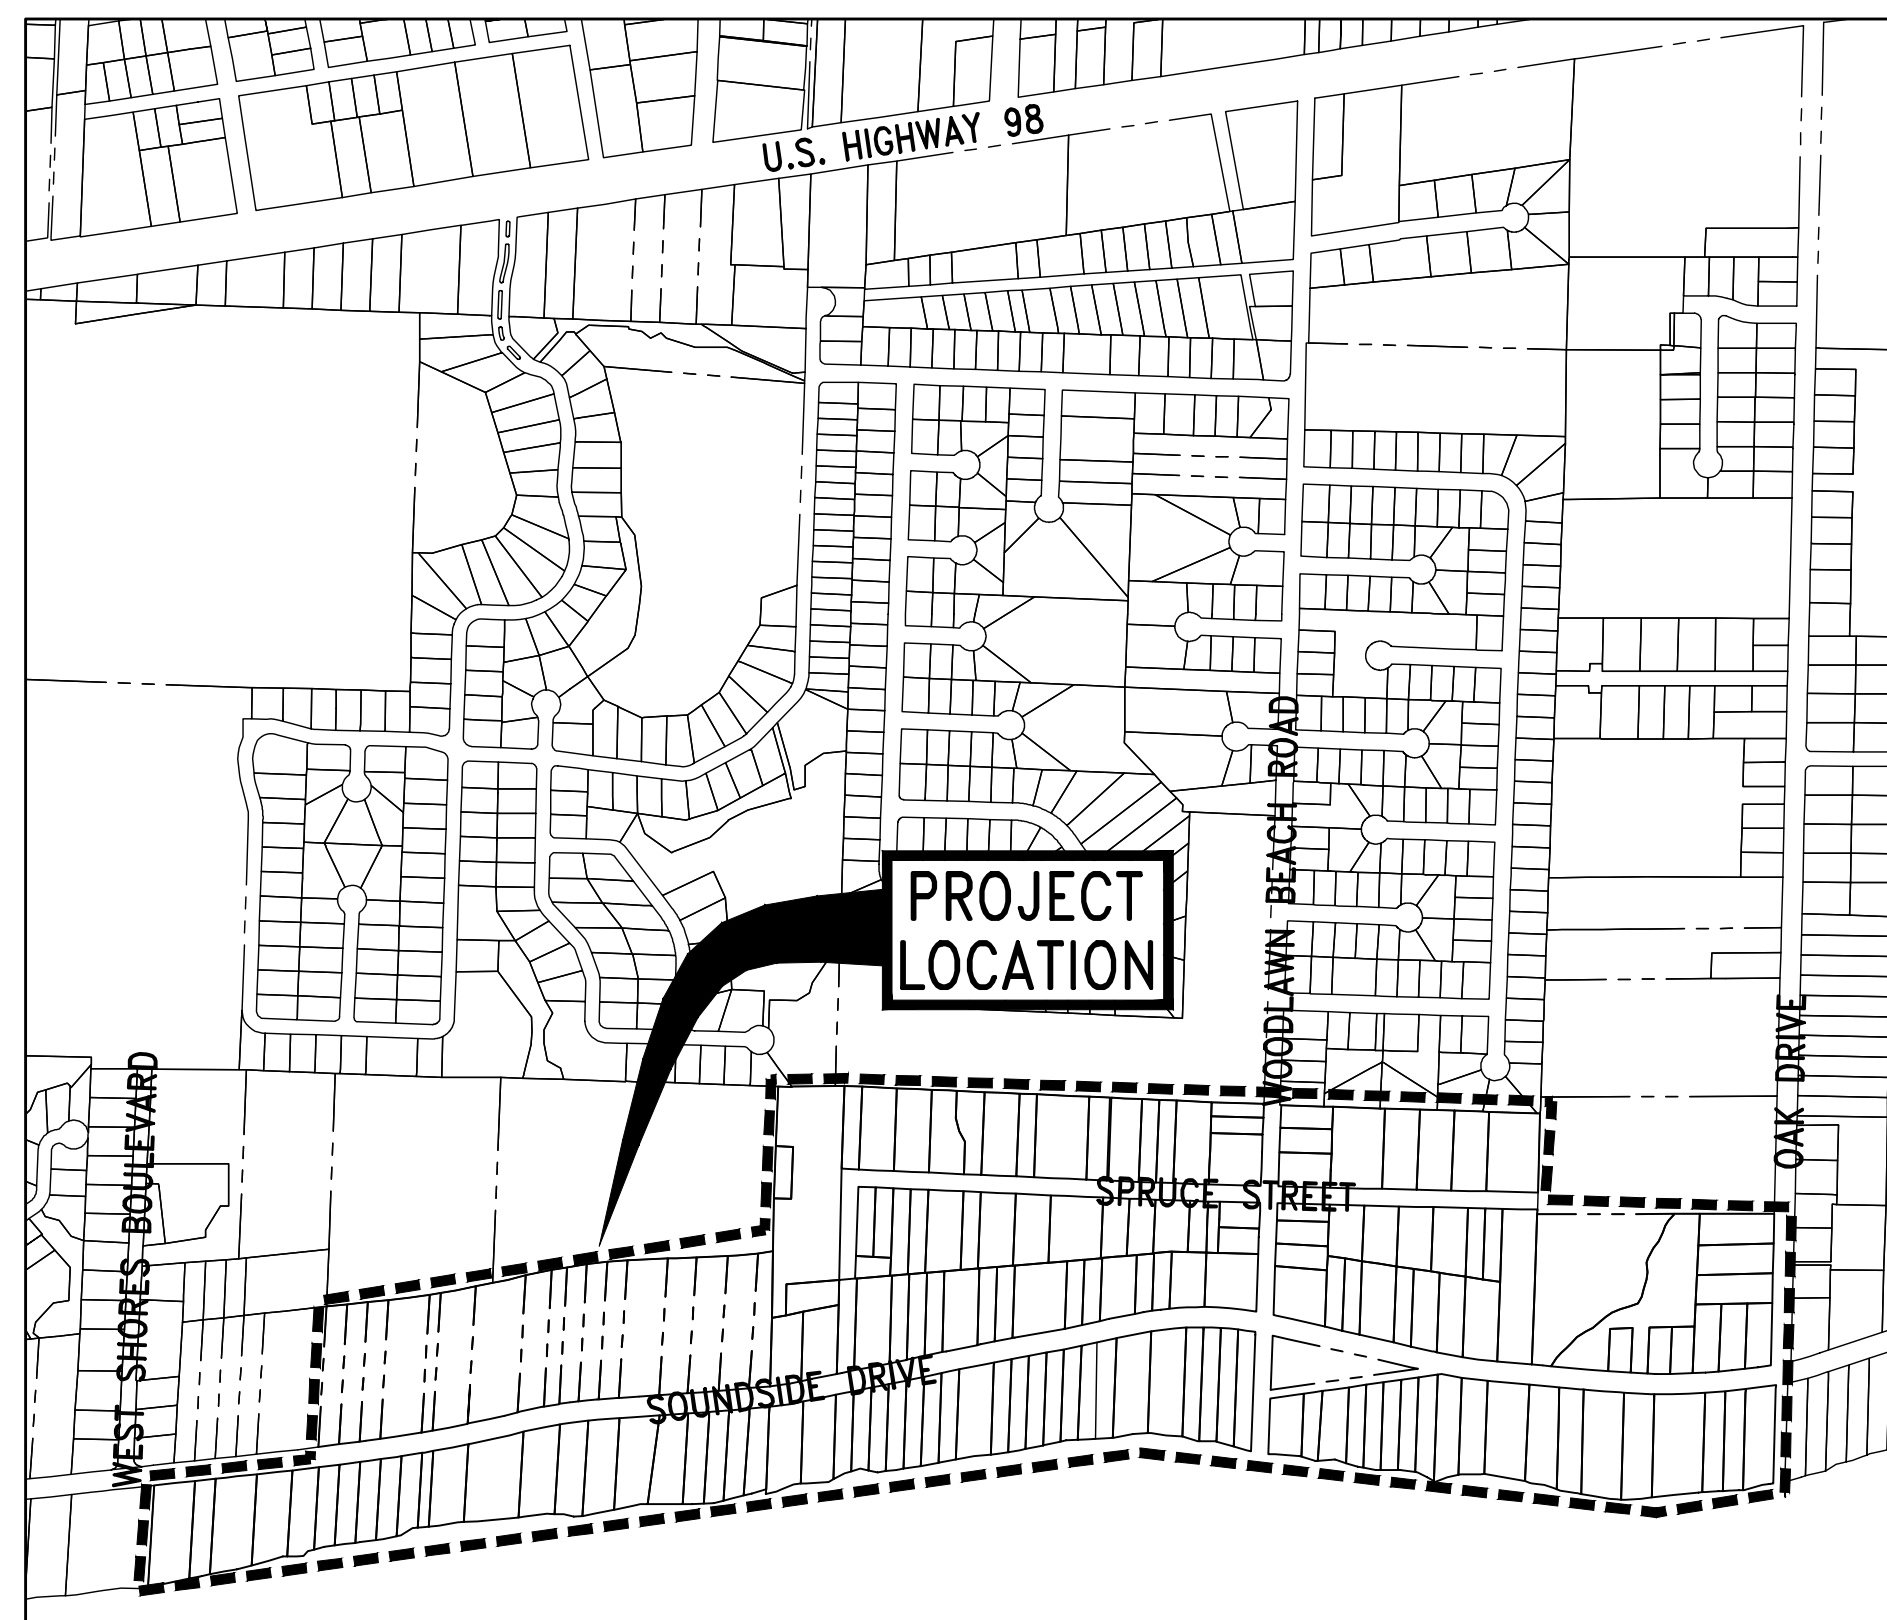

VICINITY MAP



RELEASED FOR BID

K:\204 Gulf Breeze and SSRUS\20410.46 Soundside STEP\DWG\G-001.dwg, Mor 09, 2022 - 10:36:47AM, toverton

D	GENERAL NOTES	1	2	3	4	5	ABBREVIATION LEGEND	D		
C		1.	ALL WORK SHALL BE PERFORMED IN ACCORDANCE WITH THESE PLANS AND SPECIFICATIONS AND THE REQUIREMENTS AND STANDARDS OF ALL GOVERNING AUTHORITIES INCLUDING, BUT NOT LIMITED TO, THE LATEST FDOT STANDARDS, THE LATEST FDEP STANDARDS (INCLUDING THOSE FOR SEPARATION), AND CITY OF GULF BREEZE DESIGN AND CONSTRUCTION STANDARDS.	23.	CONTRACTOR SHALL PROVIDE TO EACH PROPERTY OWNER AND THE CITY OF GULF BREEZE 2 WEEKS WRITTEN NOTICE PRIOR TO THE START OF CONSTRUCTION ADJACENT TO, OR WITHIN, THEIR PROPERTY. NOTICE SHALL INCLUDE CONTRACTOR'S NAME, ADDRESS, PHONE NUMBER AND SITE SUPERINTENDENT'S NAME AND CELL PHONE NUMBER FOR EMERGENCY CONTACT.	# & Ø	NUMBER AND AT	MAX MES MFR MH MIN MJ NTS NO	MAXIMUM MITERED END SECTION MANUFACTURER MANHOLE MINIMUM MECHANICAL JOINT NOT TO SCALE NUMBER	C
B		2.	THE CITY SHALL OBTAIN AN FDEP PERMIT FOR THE CONSTRUCTION OF A SANITARY COLLECTION SYSTEM. THE CONTRACTOR SHALL BE RESPONSIBLE FOR THE NPDES PERMITS FOR ALL GROUND WATER DISCHARGE, ALL COUNTY RIGHT-OF-WAY PERMITS, AND ANY BUILDING PERMITS ASSOCIATED WITH THE CONSTRUCTION OF THE LIFT STATION.	24.	CONTRACTOR SHALL REINSTALL/REPLACE/REPAIR ALL FENCES AND LANDSCAPING TEMPORARILY REMOVED OR DAMAGED DURING CONSTRUCTION WHETHER SHOWN ON PLANS OR NOT. VARIATIONS FROM RESTORATION TO ORIGINAL CONDITION SHALL BE APPROVED BY RESIDENT AND DOCUMENTED FOR THE CITY.	APPROX ARV AVE	APPROXIMATE (LY) AIR RELEASE VALVE AVENUE	OC OD OHE	ON CENTER OUTSIDE DIAMETER OVERHEAD ELECTRIC	B
A		3.	PRIOR TO STARTING CONSTRUCTION, THE CONTRACTOR SHALL BE RESPONSIBLE TO CONFIRM THAT ALL REQUIRED PERMITS AND APPROVALS HAVE BEEN OBTAINED. NO CONSTRUCTION OR FABRICATION SHALL BEGIN UNTIL THE CONTRACTOR HAS RECEIVED AND THOROUGHLY REVIEWED ALL PLANS AND OTHER DOCUMENTS APPROVED BY ALL OF THE PERMITTING AUTHORITIES.	25.	SEPTIC TANK/GREY WATER TANK ABANDONMENT: A. CONTRACTOR SHALL OBTAIN APPROPRIATE PERMITS FROM SANTA ROSA COUNTY DEPARTMENT OF HEALTH. DOCUMENTATION OF PERMIT AND FINAL INSPECTION BY THE HEALTH DEPARTMENT SHALL BE PROVIDED TO THE CITY. B. CONTRACTOR SHALL HAVE EACH SEPTIC TANK PUMPED OUT AND CONTENTS PROPERLY DISPOSED OF. C. CONTRACTOR SHALL REMOVE AND PROPERLY DISPOSE OF SEPTIC TANK TOP SECTIONS. D. CONTRACTOR SHALL BREAK OUT THE BOTTOM OF EACH SEPTIC TANK. E. CONTRACTOR SHALL BREAK OUT THE TOP 3' OF THE SEPTIC TANK WALL AND REMOVE. F. CONTRACTOR SHALL BACKFILL ALL VOIDS AND COMPACT IN 12" LIFTS. WET SOIL AS REQUIRED BY GEOTECHNICAL REPORT TO ACHIEVE COMPACTION. G. CONTRACTOR SHALL SOD AS REQUIRED TO MATCH EXISTING YARD.	B/ BLDG BM	BOTTOM OF BUILDING BENCHMARK	PS PVC PVMT PW	PUMP STATION POLYVINYL CHLORIDE PIPE PAVEMENT POTABLE WATER	A
		4.	THE LOCATIONS OF UNDERGROUND UTILITIES SHOWN ON THESE PLANS ARE BASED ON INFORMATION PROVIDED BY THE UTILITIES AND ARE TO BE CONSIDERED APPROXIMATE. IT SHALL BE THE CONTRACTOR'S FULL RESPONSIBILITY TO CONTACT THE VARIOUS UTILITY COMPANIES TO LOCATE THEIR FACILITIES PRIOR TO STARTING CONSTRUCTION. NO ADDITIONAL COMPENSATION SHALL BE PAID TO THE CONTRACTOR FOR DAMAGE AND REPAIR TO THESE FACILITIES CAUSED BY HIS WORK FORCE. CONTRACTOR SHALL BE RESPONSIBLE FOR REPAIR OF ANY DAMAGED UTILITIES.	26.	ALL VALVE BOXES SHALL BE SET FLUSH AND TO FINISH GRADE. ALL BOXES SHALL BE MARKED AS "SEWER".	CAP CLR CMP CO CONC CTR	CAPACITY CLEAR CORRUGATED METAL PIPE CLEAN OUT CONCRETE CENTER (ED)	R/W RCP RED REQ'D RT	RIGHT-OF-WAY REINFORCED CONCRETE PIPE REDUCER REQUIRED RIGHT	
		5.	THE CONTRACTOR SHALL NOTIFY THE SUNSHINE STATE ONE CALL OF FLORIDA, SUPERINTENDENTS OF THE WATER, SANITARY SEWER, GAS, TELEPHONE, CABLE TELEVISION AND POWER COMPANIES 14 DAYS IN ADVANCE THAT HE INTENDS TO START WORK IN A SPECIFIC AREA. THE OWNER DISCLAIMS ANY RESPONSIBILITY FOR THE SUPPORT AND PROTECTION OF SEWERS, DRAINS, WATER PIPES, GAS PIPES, CONDUITS OF ANY KIND, UTILITIES OR OTHER STRUCTURES OWNED BY THE CITY, COUNTY, STATE OR BY PRIVATE OR PUBLIC UTILITIES OCCUPYING ANY STREET, ALLEY, PUBLIC PLACE OR RIGHT-OF-WAY.	27.	IT SHALL BE THE CONTRACTOR'S RESPONSIBILITY TO COORDINATE THE LOCATION OF SEPTIC TANKS WITH EACH PROPERTY OWNER OR THEIR DESIGNATED REPRESENTATIVE AND IDENTIFY THE BEST ROUTE TO INSTALL SEWER LATERAL FROM HOUSE TO RIGHT-OF-WAY. SEWER LATERAL STUB-OUTS ARE SHOWN ON THE DRAWING BUT SHALL BE FIELD LOCATED BASED ON CONTRACTOR'S NEGOTIATION WITH THE PROPERTY OWNER.	DEPT DI DIA DIP DSY	DEPARTMENT DUCTILE IRON DIAMETER DUCTILE IRON PIPE DOUBLE SOLID YELLOW LINE	SAN SBW SBY SD SHT SS SSW ST STA STD	SANITARY SEWER SINGLE BROKEN WHITE LINE SINGLE BROKEN YELLOW LINE STORM DRAIN SHEET STAINLESS STEEL OR SANITARY SEWER SINGLE SOLID WHITE LINE STORM INLET STATION STANDARD	
		6.	PROPERTY OBSTRUCTIONS WHICH ARE TO REMAIN IN PLACE, SUCH AS BUILDINGS, SEWER DRAINS, WATER OR GAS PIPES, CONDUITS, CABLES, POLES, WALLS, POSTS, ETC., ARE TO BE CAREFULLY PROTECTED. CONTRACTOR SHALL NOTIFY ENGINEER PRIOR TO REMOVING ANY OBSTRUCTIONS NOT SPECIFICALLY NOTED ON THE PLANS.	28.	ALL DISTURBED DRIVEWAYS SHALL BE REMOVED TO THE NEAREST EXPANSION JOINT OR SAW CUT TO BEYOND THE APRON. MINIMUM WIDTH OF SAW CUT SHALL BE 5'. DRIVEWAYS SHALL BE RESTORED WITH LIKE MATERIALS. TRANSITION FROM DRIVEWAY TO ASPHALT ROADWAY SHALL BE FLUSH. FOR OVERLAYS AT UNDISTURBED DRIVEWAYS, CONTRACTOR SHALL SAW CUT APRON BACK MINIMUM 2' FROM EDGE OF PAVEMENT. AFTER ROAD OVERLAY, CONTRACTOR SHALL RESTORE DRIVEWAY WITH LIKE MATERIALS SO THAT JOINT WITH ASPHALT IS FLUSH.	E ECP EL ELEC EOP EQV ERCP EX, EXIST	EAST REINFORCED CONCERETE PIPE ELEVATION ELECTRIC(AL) EDGE OF PAVEMENT EQUIVALENT ELLIPTICAL REINFORCED CONCRETE PIPE EXISTING	T/ TBM TEMP TOS TOW TYP	TOP OF TEMPORARY BENCH MARK TEMPORARY TOP OF SLAB TOP OF WALL TYPICAL	
		7.	RELOCATION OF OBSTRUCTIONS OWNED BY PRIVATE PROPERTY OWNERS SUCH AS MAIL BOXES AND FENCING, SHALL BE THE RESPONSIBILITY OF THE CONTRACTOR WHO MUST COORDINATE WITH THE PROPERTY OWNER.	29.	CONTRACTOR TO REPAIR/REPLACE ALL DAMAGED DRIVEWAY CULVERTS.	FDOT FF FH FLG FM FT	FLORIDA DEPARTMENT OF TRANSPORTATION FINISH FLOOR FIRE HYDRANT FLANGE FORCE MAIN FEET/FOOT	VERT VOL	VERTICAL VOLUME	
		12.	ALL EXCESS FILL FROM SITE SHALL BE STOCKPILED BY THE CONTRACTOR IN A LOCATION DETERMINED BY THE OWNER OR THE OWNER'S REPRESENTATIVE AND THE ENGINEER.	30.	CONTRACTOR IS REQUIRED TO COMMUNICATE ROAD CLOSURES TO EMERGENCY SERVICES, THE SCHOOL SYSTEM FOR BUS ROUTING AND SANITATION SERVICES.	GA G	GAUGE GAS	W W/ W/O WM WWF	WIDTH OR WATER WITH WITHOUT WATER MAIN WELDED WIRE FABRIC	
		13.	CONTRACTOR SHALL BE FULLY RESPONSIBLE FOR CONTROL OF ALL EROSION AND SEDIMENTATION.	31.	EXISTING STORMWATER IMPROVEMENTS, INCLUDING STORMWATER PIPE WITH GRAVEL BED AND SOCK SHALL BE PROTECTED. DAMAGED SECTIONS SHALL BE REPAIRED/REPLACED INCIDENTAL TO THE PROJECT.	H	HORIZONTAL	ID IN INV	INSIDE DIAMETER INCH INVERT	
		15.	PRIOR TO BID SUBMISSION, CONTRACTOR SHALL VISIT SITE TO FAMILIARIZE HIMSELF WITH EXISTING CONDITIONS AND THE EXTENT OF CLEARING AND GRUBBING REQUIRED.	35.	CONTRACTOR TO PROVIDE ENGINEER WITH A COMPLETE SET OF "RECORD DRAWINGS", INCLUDING BUT NOT LIMITED TO, FINISHED GRADES, LOCATION AND INVERTS OF ALL STRUCTURES AND UTILITIES.	L LBS LF LG LR LT	LENGTH POUNDS LINEAR FEET LONG LONG RADIUS LEFT	APPR. JEA	DATE 02/22	
		16.	ALL DIMENSIONS AND GRADES SHOWN ON THE PLANS SHALL BE FIELD VERIFIED BY THE CONTRACTOR PRIOR TO CONSTRUCTION. CONTRACTOR SHALL NOTIFY THE ENGINEER IF ANY DISCREPANCIES EXIST PRIOR TO PROCEEDING WITH CONSTRUCTION FOR NECESSARY PLAN OR GRADE CHANGES. NO EXTRA COMPENSATION SHALL BE PAID TO THE CONTRACTOR FOR WORK HAVING TO BE REDONE DUE TO DIMENSIONS OR GRADES SHOWN INCORRECTLY ON THESE PLANS IF SUCH NOTIFICATION HAS NOT BEEN GIVEN.	36.	CONSTRUCTION INSPECTION WILL BE PROVIDED BY THE OWNER'S REPRESENTATIVE. THE CONTRACTOR SHALL NOTIFY THE OWNER AT LEAST 48 HOURS PRIOR TO BEGINNING CONSTRUCTION AND AT LEAST 48 HOURS BEFORE REQUIRING INSPECTION ON EACH AND EVERY PHASE OF WORK. NO FINAL TESTING OR PRESSURE TESTING WILL BE ACCEPTED UNLESS WITNESSED BY THE OWNER'S REPRESENTATIVE.	NO	1	PROJECT NO: 20410.46	DESIGNED BY: KMS	
		17.	CONTRACTOR SHALL BE COMPLETELY RESPONSIBLE FOR THE LAYOUT OF THE WORK. ANY DEVIATION NOT NOTED ON THESE PLANS FROM THE PRESCRIBED ALIGNMENT, NECESSARY TO AVOID CONFLICTS, SHALL NOT BE PERMITTED WITHOUT WRITTEN PERMISSION FROM THE ENGINEER OR OWNER. ALL DEVIATIONS SHALL BE DOCUMENTED BY THE CONTRACTOR ON THE "AS-BUILT" DRAWINGS. ALL MEASUREMENTS ARE TAKEN FROM THE CENTERLINE OF THE PIPE.	37.	ANY SURVEY MONUMENTATION DISTURBED DURING CONSTRUCTION SHALL BE REPLACED UPON COMPLETION OF THE WORK BY A REGISTERED LAND SURVEYOR.	DRAWN BY: THO	CHK'D BY: JEA	PROJ. MGR: RMD	DATE: FEBRUARY 2022	
		18.	CONTRACTOR TO COORDINATE WITH RESPONSIBLE UTILITY FOR PROTECTION/HOLDING OF UTILITY POLES, GUY WIRES AND GUY ANCHORS IN AREAS OF CONSTRUCTION.	38.	PLANS AND SPECIFICATIONS REQUIRE THAT COMPACT BACKFILL BE PLACED ALONG SIDE OF AND OVER ALL UTILITIES. THE ENGINEER MAY REQUIRE THAT COMPACTION TESTS BE TAKEN TO VERIFY BACKFILL COMPACTION. THE COST OF SUCH COMPACTION TESTS WILL BE BORNE BY THE CONTRACTOR.	GENERAL NOTES AND ABBREVIATION LEGEND	G-001			
		19.	THE ENGINEER AND OWNER'S REPRESENTATIVE SHALL BE NOTIFIED A MINIMUM OF 48 HOURS IN ADVANCE OF THE PRESSURE AND LEAKAGE TEST. THE PRESSURE TEST SHALL BE PERFORMED IN ACCORDANCE WITH AWWA STANDARDS.	39.	THE CONTRACTOR IS RESPONSIBLE FOR THE PROTECTION OF ALL TREES, MONITORING WELLS, STRUCTURES AND UTILITIES NOT MARKED FOR REMOVAL OR DEMOLITION AND SHALL PROMPTLY REPAIR ANY DAMAGE AS DIRECTED BY THE ENGINEER AT NO COST TO THE OWNER.					
		20.	CONTRACTOR TO MAINTAIN ACCESS TO ALL PROPERTIES WITHIN PROJECT AREA AT ALL TIMES.	40.	CONTRACTOR SHALL REMOVE ALL UNSALVAGEABLE MATERIALS AND YARD WASTE FROM THE SITE IMMEDIATELY AND DISPOSE OF IN ACCORDANCE WITH ALL APPLICABLE FEDERAL, STATE AND LOCAL REGULATIONS.					
		21.	MINIMUM GROUND COVER OVER PROPOSED SEWER IS 36" UNLESS OTHERWISE NOTED OR APPROVED.							
		22.	MAINTENANCE OF EXISTING AND SETTING OF NEW HORIZONTAL AND VERTICAL CONTROLS SHALL BE THE CONTRACTOR'S RESPONSIBILITY.							

BASKERVILLE-DONOVAN, INC.
Innovative Infrastructure Solutions
449 W. MAIN ST., PENSACOLA, FL 32502 (850) 438-9861
ENGINEERING BUSINESS: EB-00000340
Pensacola - Panama City Beach - Tallahassee - Mobile

This drawing is the property of BASKERVILLE-DONOVAN, INC. and is not to be reproduced in whole or in part. It is not to be used on any other project and is to be returned upon request.

SSRUS SOUNDSIDE SEPTIC TANK ELIMINATION PROGRAM PHASE B

SANTA ROSA COUNTY, FLORIDA

PROJECT NO: 20410.46

DESIGNED BY: KMS

DRAWN BY: THO

CHK'D BY: JEA

PROJ. MGR: RMD

DATE: FEBRUARY 2022

GENERAL NOTES AND ABBREVIATION LEGEND

G-001

M,

001

041

✓




001


041


✓

K:\204 Gulf Breeze and SSRUS\20410.46 Soundside STEP\DWG\C-100.dwg, Feb 02, 2022 - 10:32:22AM, toverton

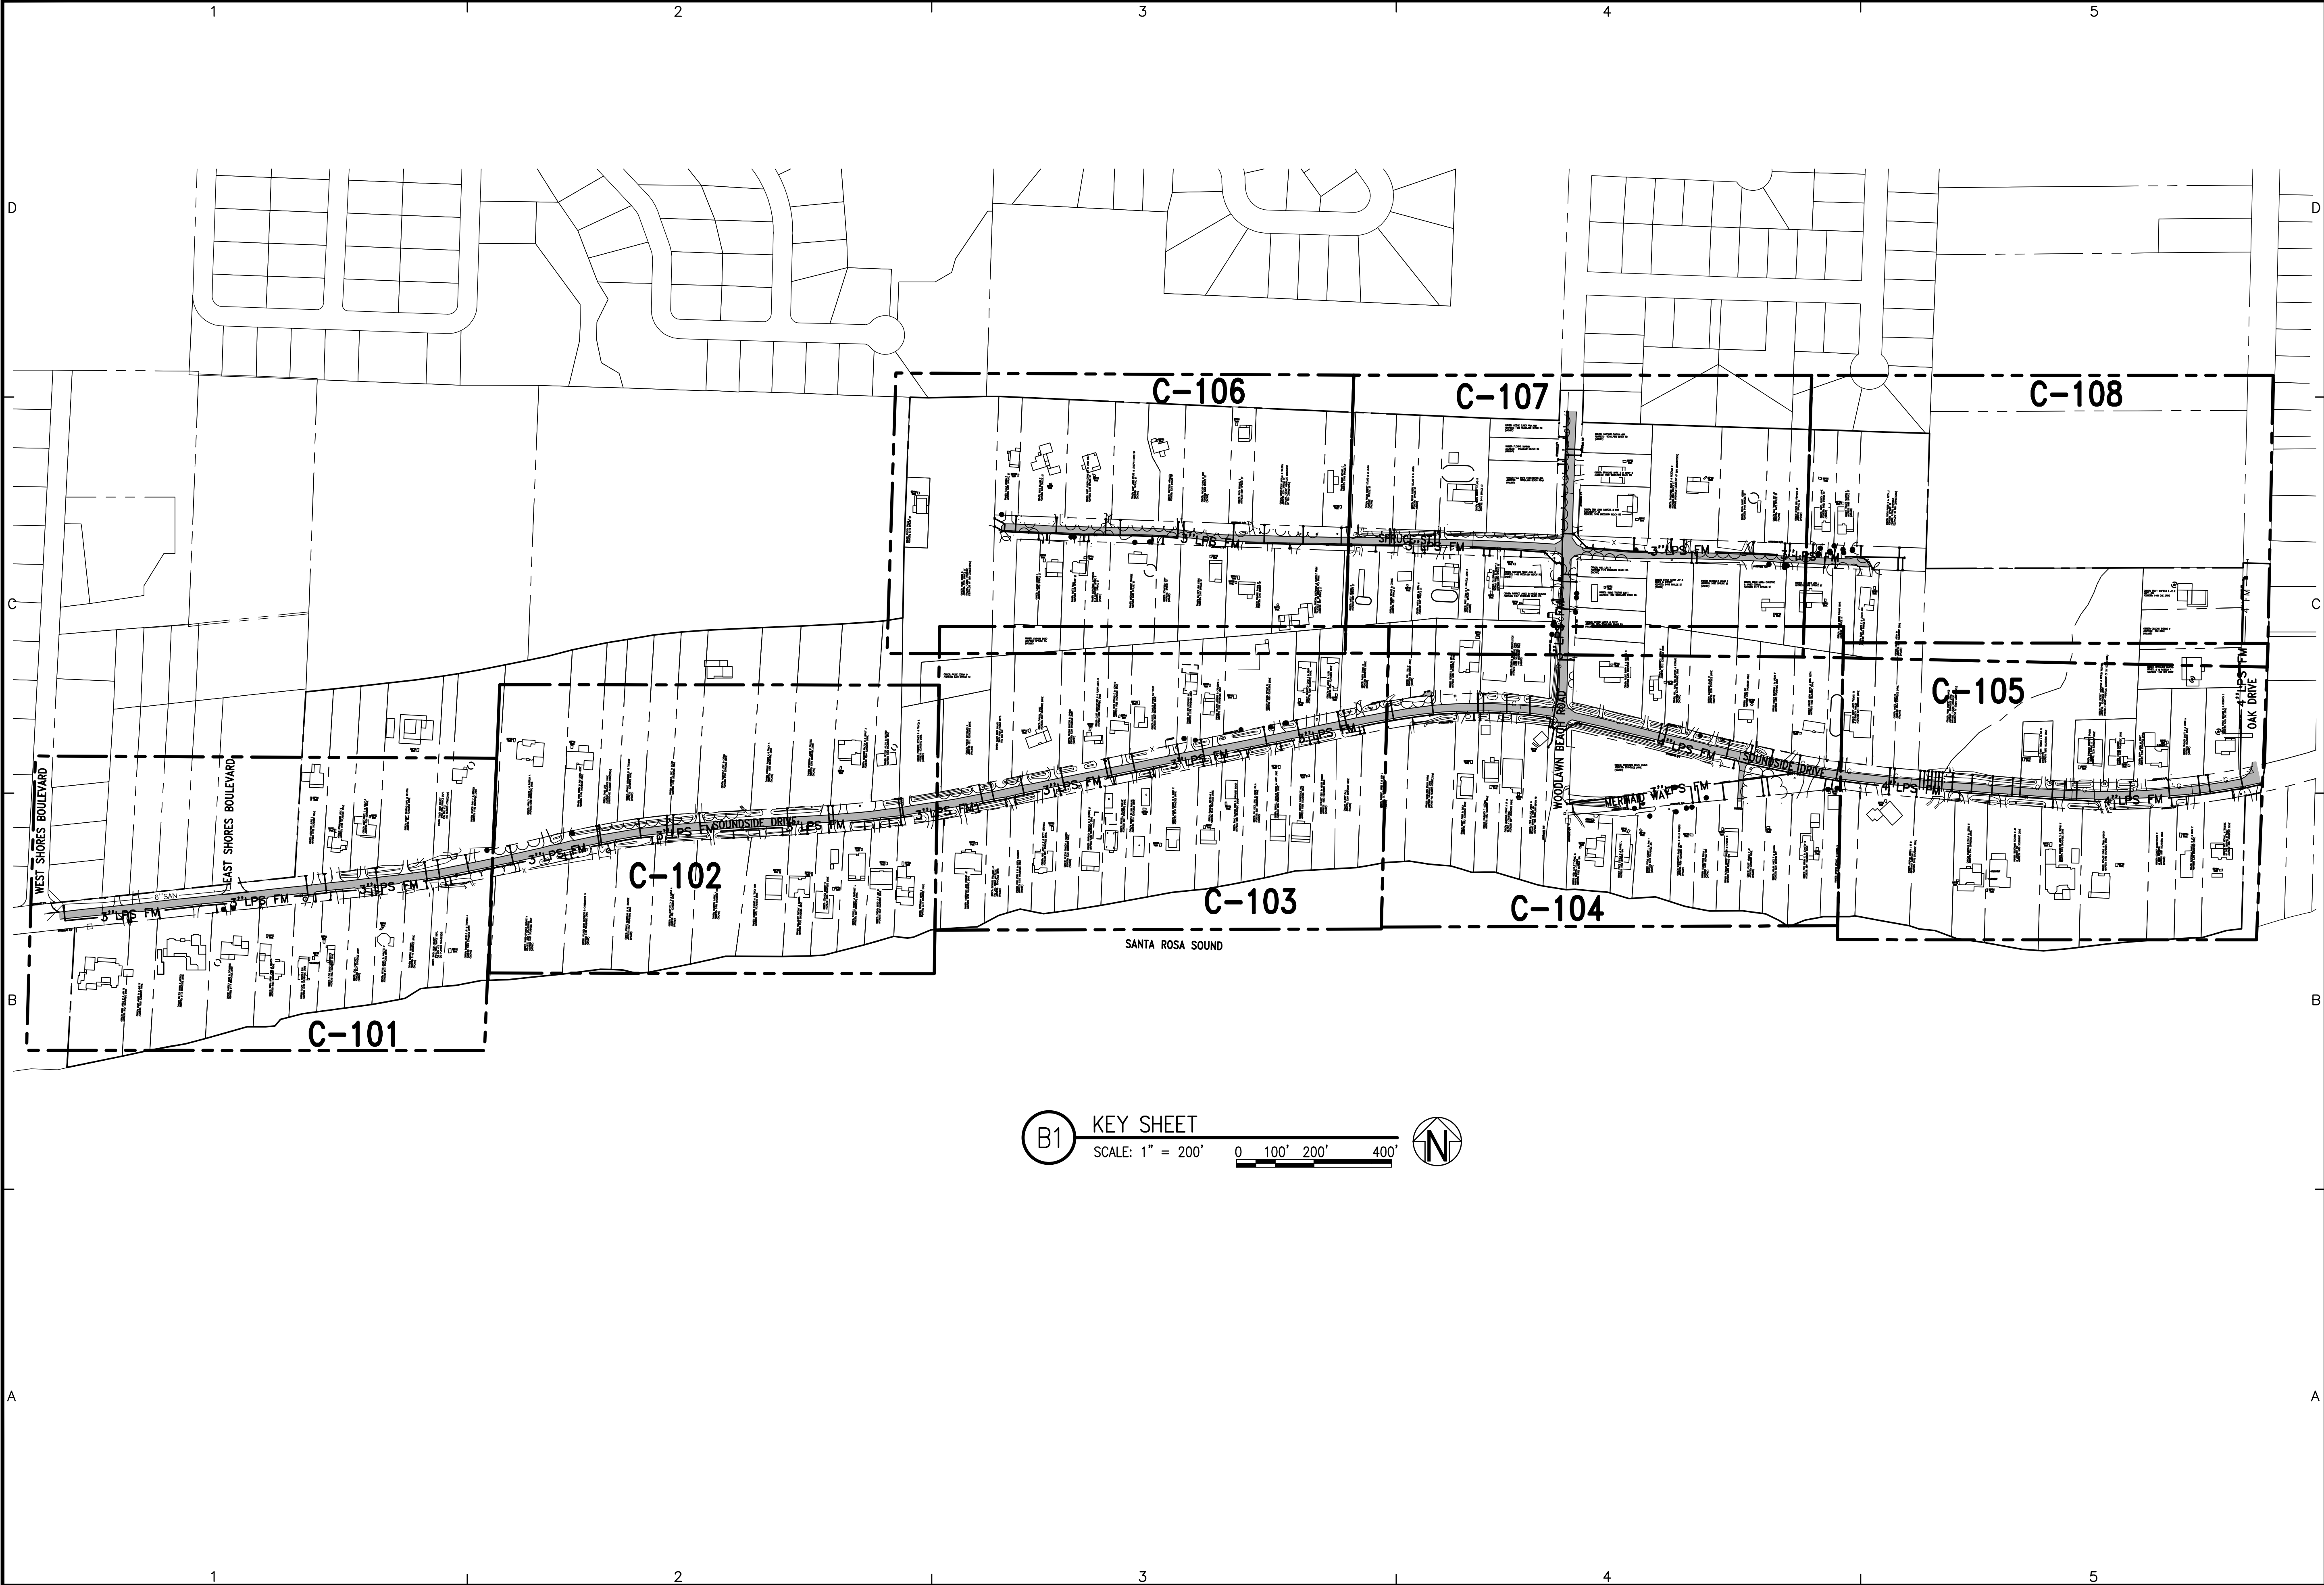

C-100	SANITARY SEWER ROUTE KEY SHEET	PROJECT NO:	20410.46	NO.	DATE	APPR.	REVISION/ACTION TAKEN		SSRUS SOUNDSIDE SEPTIC TANK ELIMINATION PROGRAM PHASE B	JAMES E. ANDERSON, P.E. FL Reg. Engineer #67494	 BASKERVILLE-DONOVAN, INC. Innovative Infrastructure Solutions 449 W. MAIN ST., PENSACOLA, FL 32502 (850) 438-9861 ENGINEERING BUSINESS: EB-0000340 Pensacola - Panama City Beach - Tallahassee - Mobile This drawing is the property of BASKERVILLE-DONOVAN, INC. and is not to be reproduced in whole or in part. It is not to be used on any other project and is to be returned upon request.
		DESIGNED BY: KMS		1	01/22	JEA	RELEASED FOR BID				
		DRAWN BY: THO									
		CHK'D BY: JEA									
		PROJ. MGR: RWD									
DATE: JANUARY 2022		NOT RELEASED FOR CONSTRUCTION BY		DATE	SANTA ROSA COUNTY, FLORIDA						

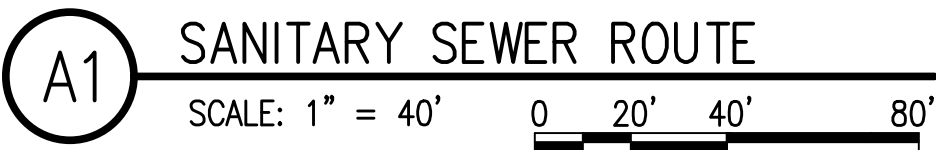

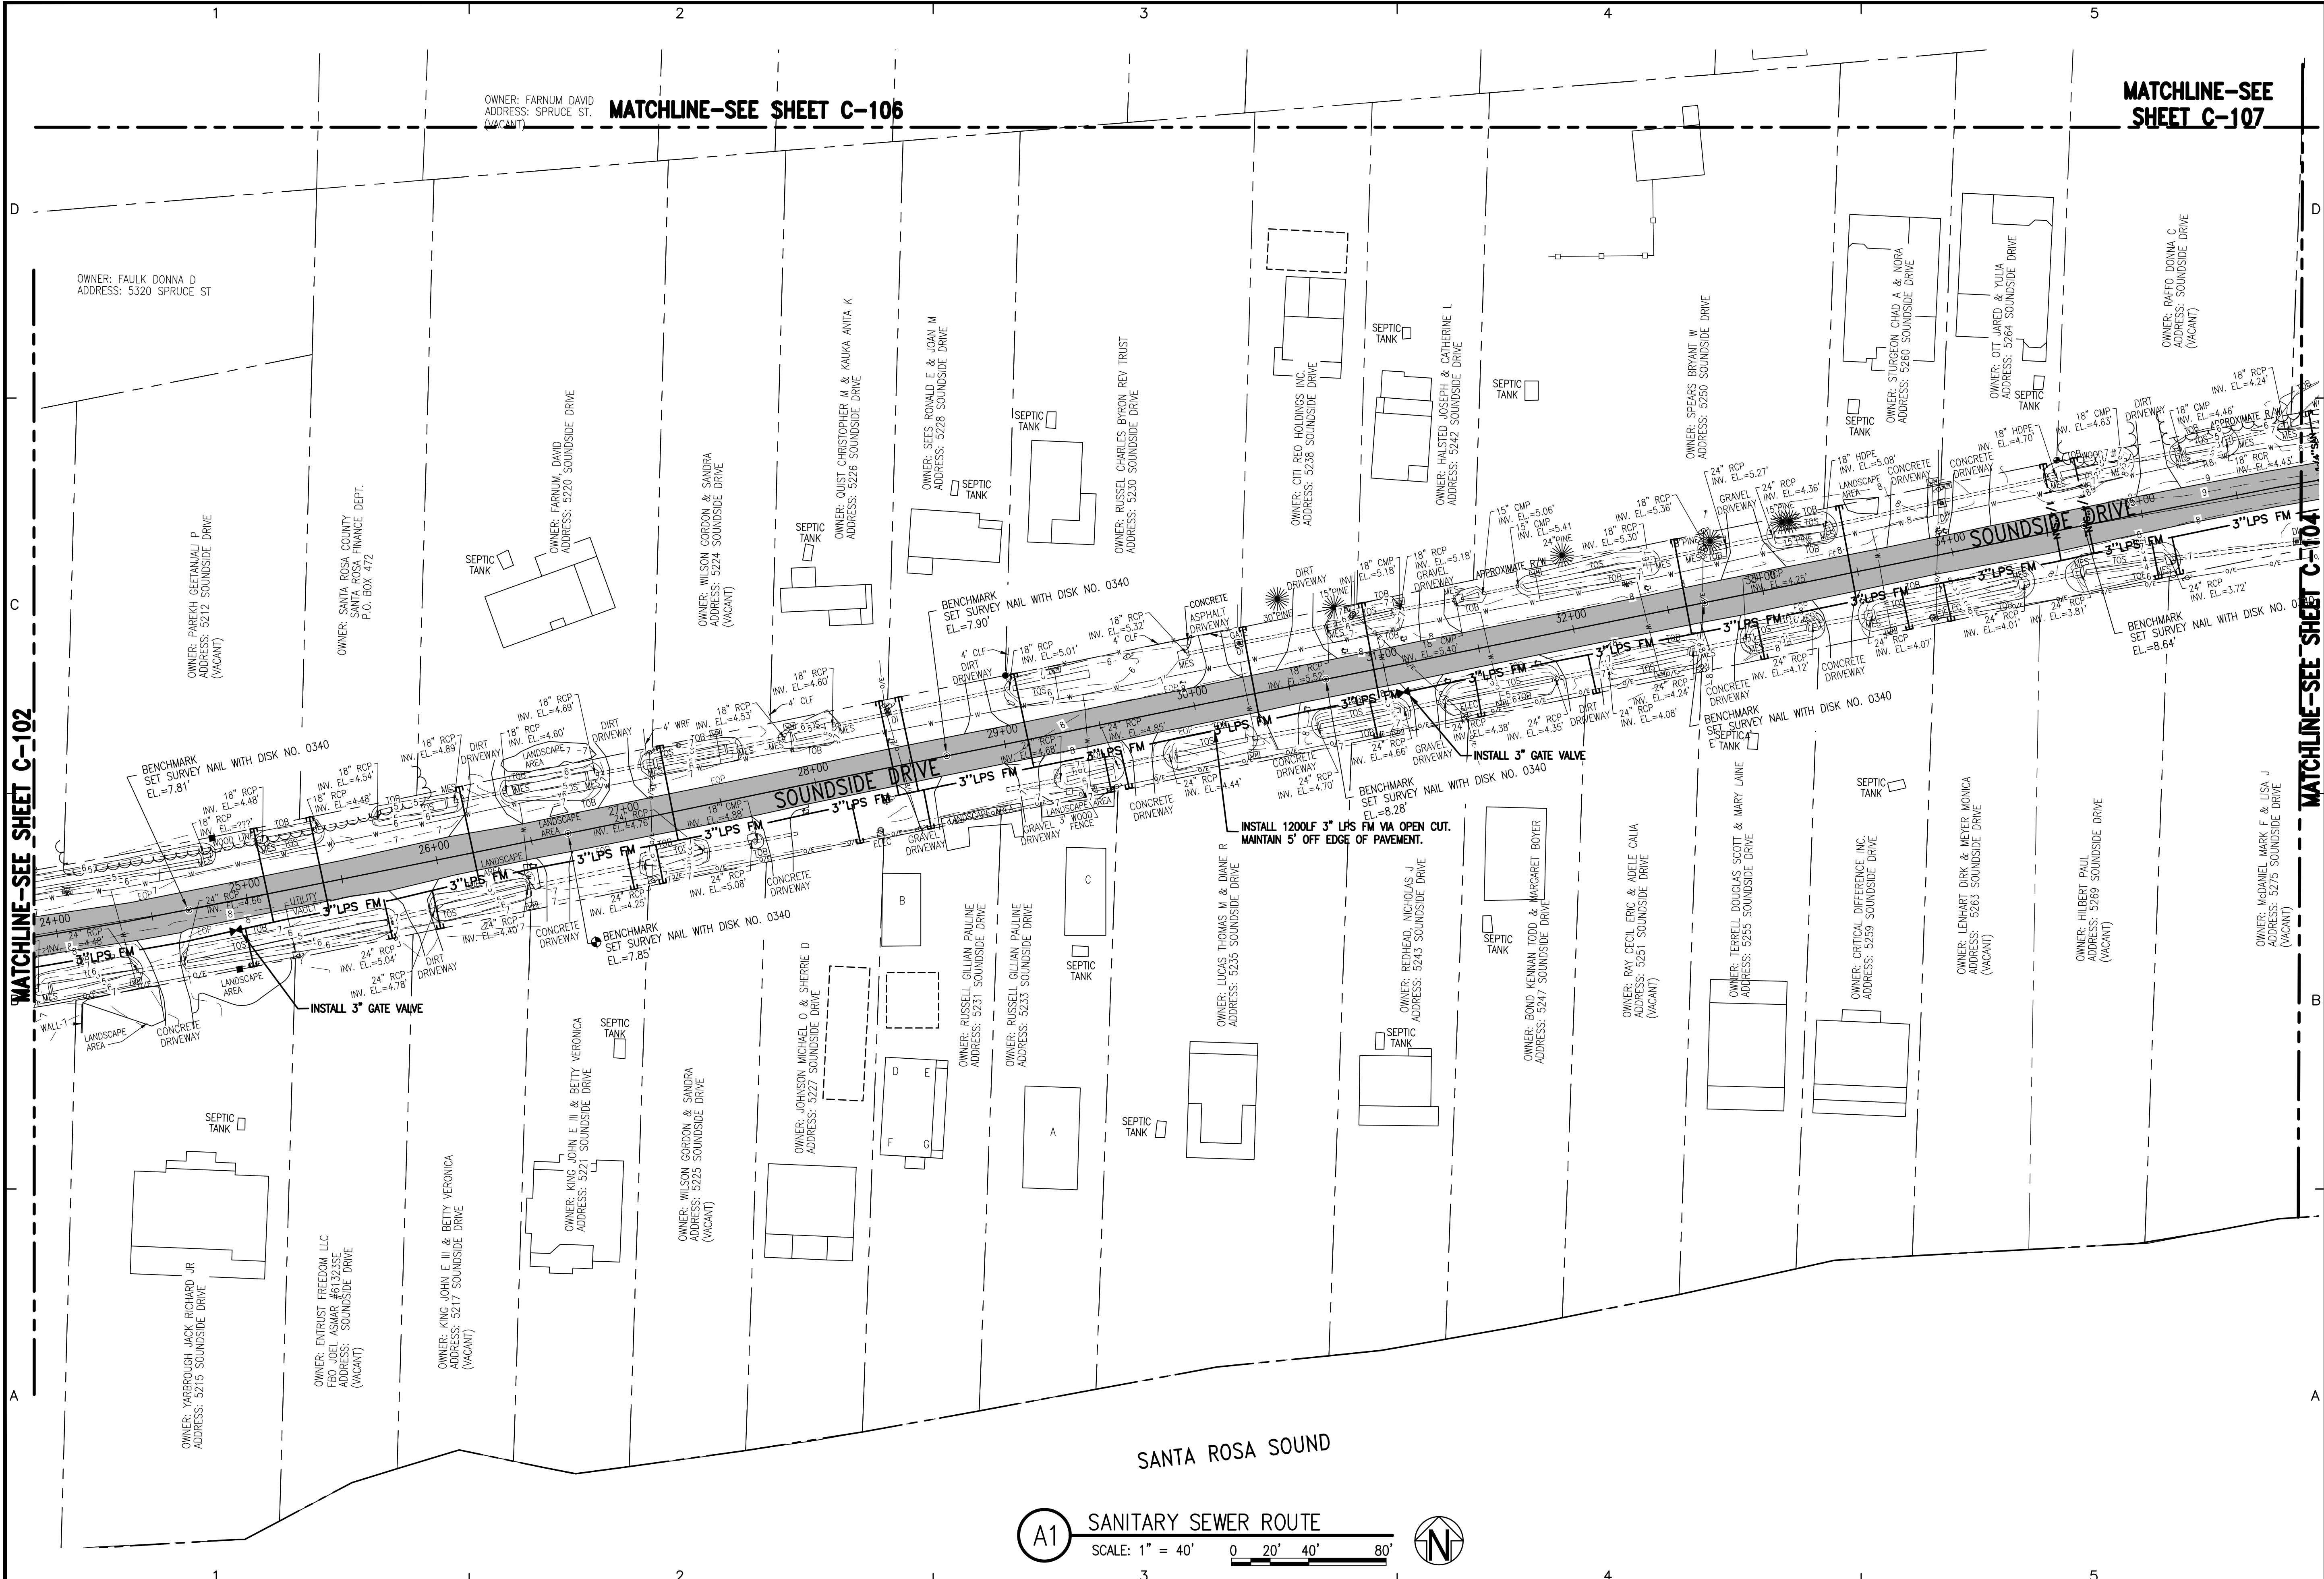

SANITARY SEWER ROUTE SOUNDSIDE DRIVE	PROJECT NO.	20410.46	NO.	1	DATE	02/22	APPR.	JEA	REVISION/ACTION TAKEN	RELEASED FOR BID
	DESIGNED BY:	KMS								
	DRAWN BY:	THO								
	CHK'D BY:	JEA								
	PROJ. MGR:	RWD								
	DATE:	FEBRUARY 2022							NOT RELEASED FOR CONSTRUCTION BY	DATE
C-103										

BASKERVILLE-DONOVAN, INC.
Innovative Infrastructure Solutions
449 W. MAIN ST. PENSACOLA, FL 32502 (850) 438-9861
ENGINEERING BUSINESS: EB-00000340

Pensacola - Panama City Beach - Tallahassee - Mobile



JAMES E. ANDERSON, P.E.
FL Reg. Engineer #87494

SSRUS SOUNDSIDE SEPTIC TANK ELIMINATION PROGRAM PHASE B

SANTA ROSA COUNTY, FLORIDA


MATCHLINE-SEE SHEET C-107

MATCHLINE-SEE SHEET C-102

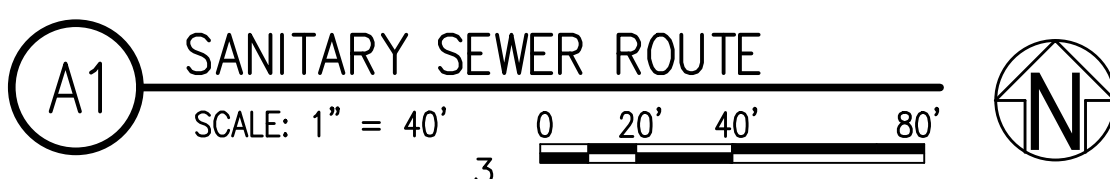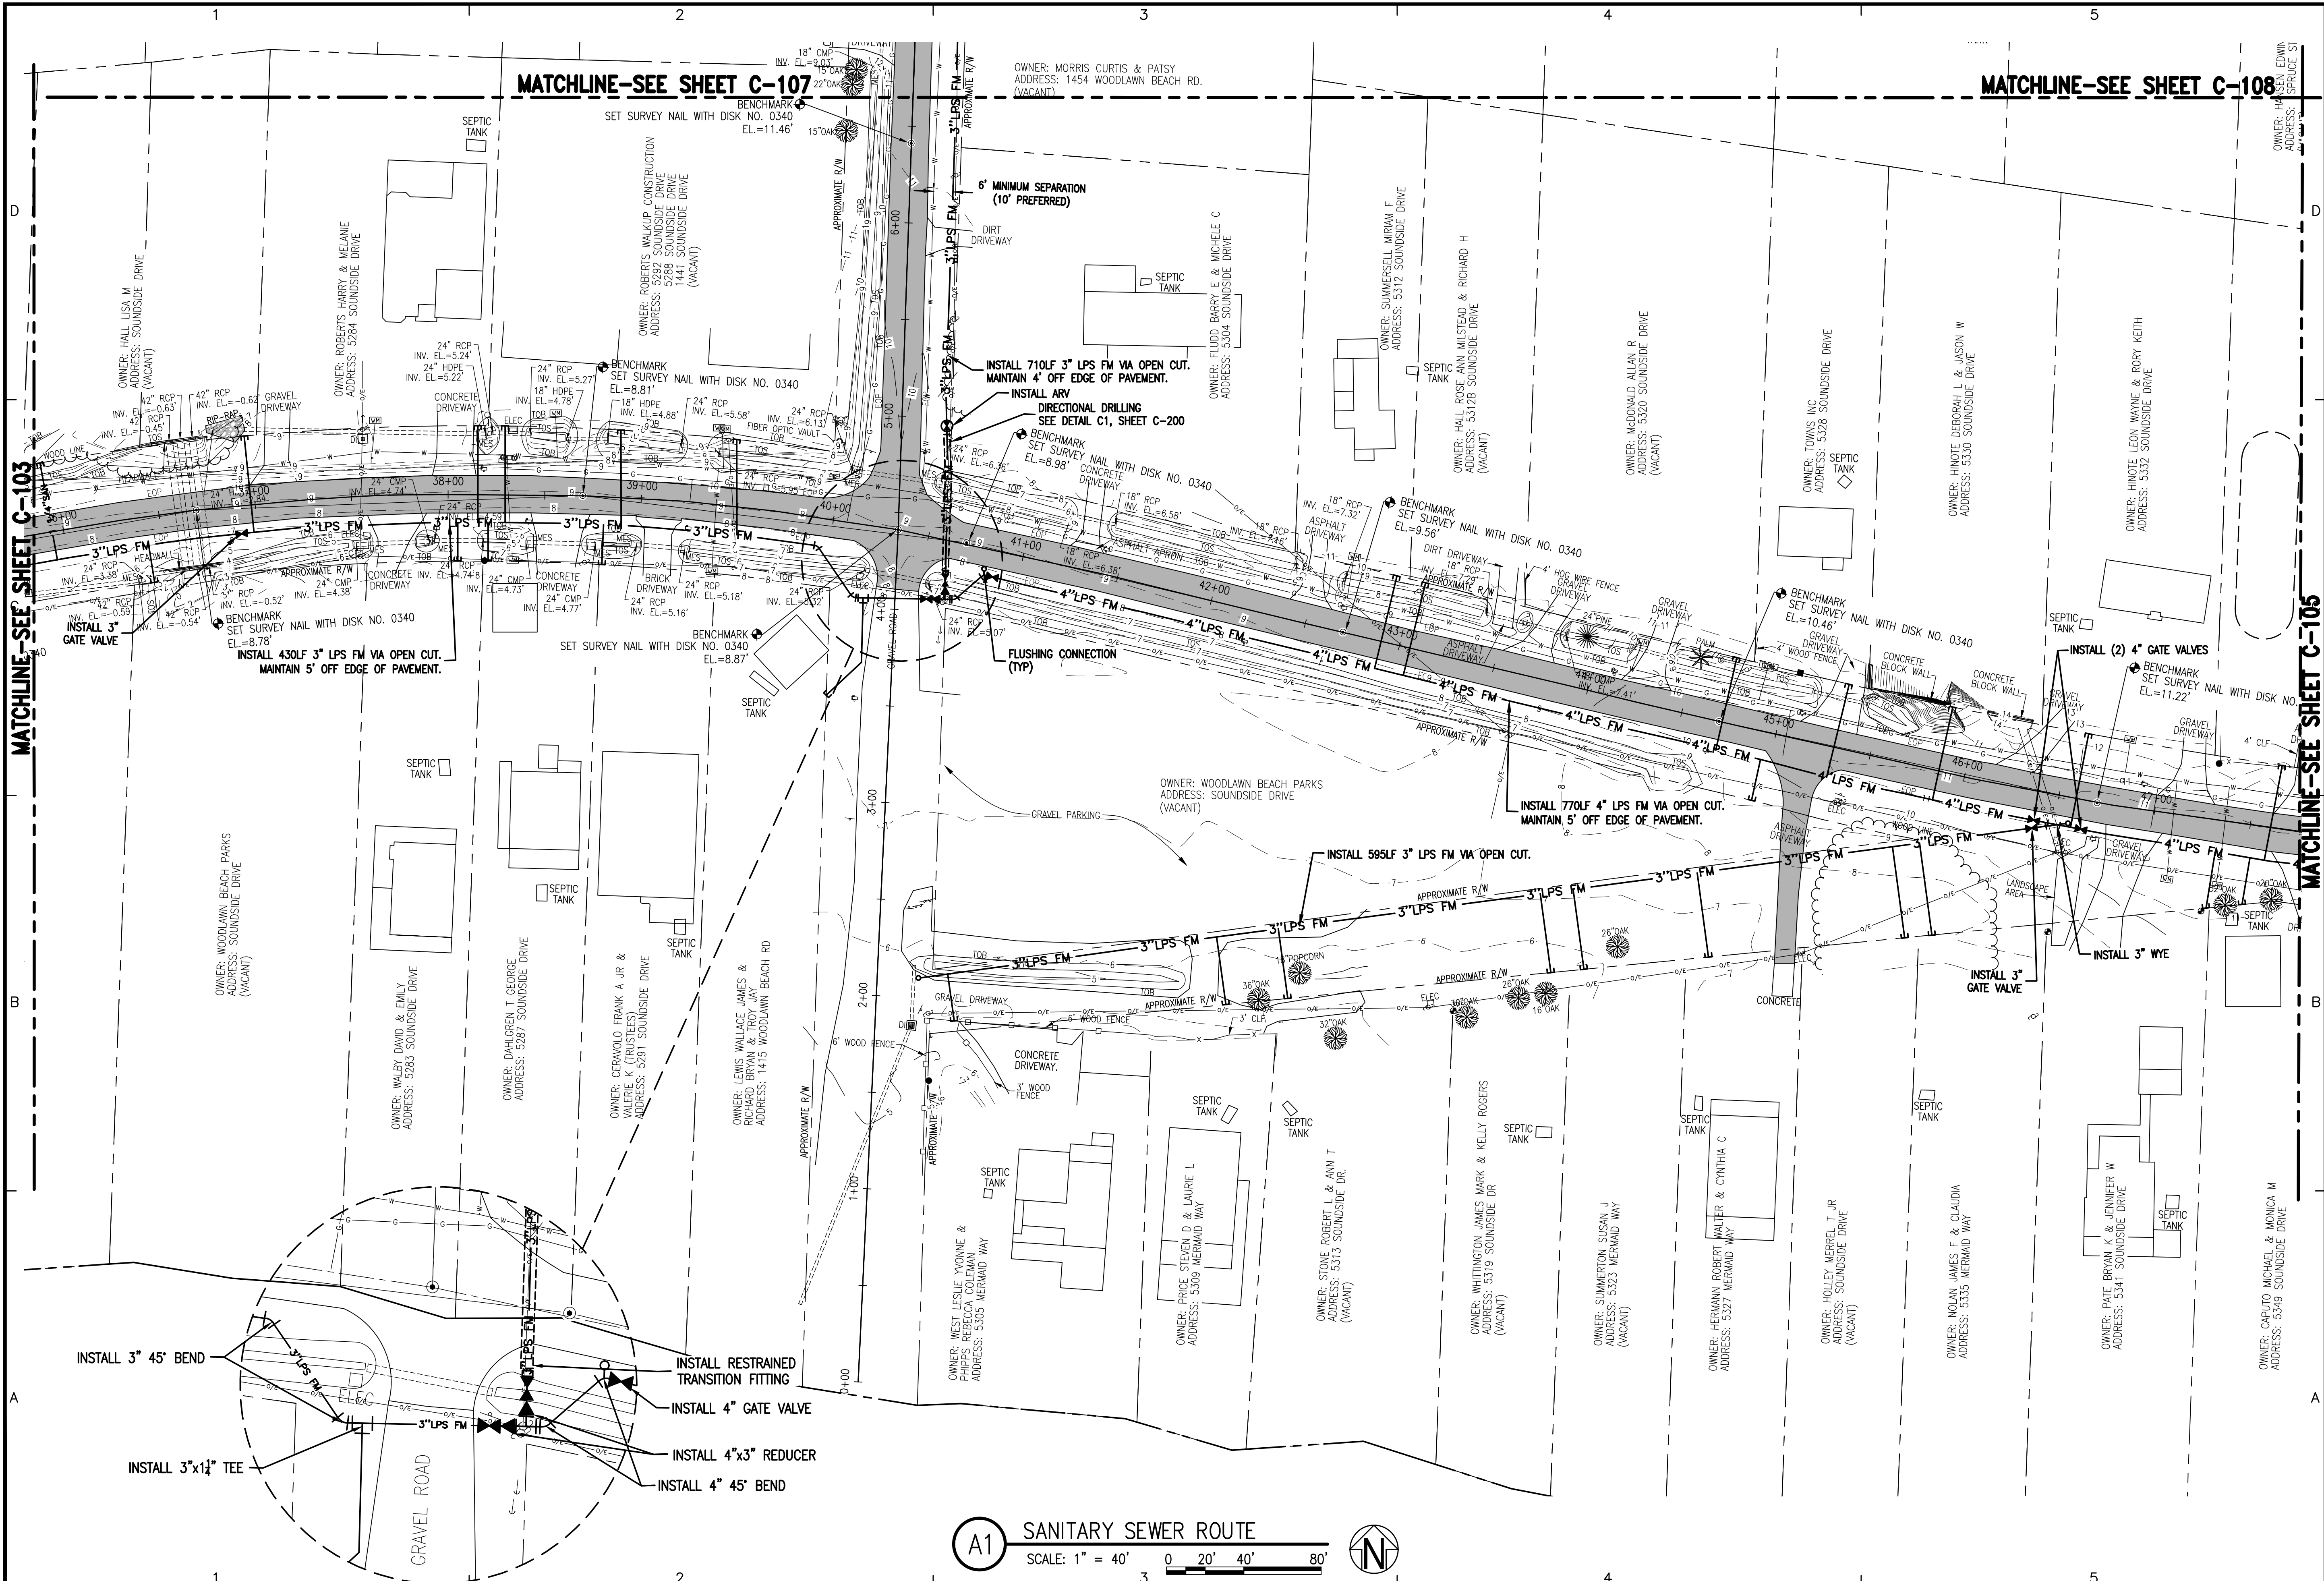


BASKERVILLE-DONOVAN, INC. Innovative Infrastructure Solutions 449 W. MAIN ST., PENSACOLA, FL 32502 (850) 438-9881 ENGINEERING BUSINESS: EB-0000340 Pensacola - Panama City Beach - Tallahassee - Mobile	SSRS SOUNDSIDE SEPTIC TANK ELIMINATION PROGRAM PHASE B			
	SANTA ROSA COUNTY, FLORIDA			
	PROJECT NO:	20410.46	NO.	1
	DESIGNED BY:	KMS	DATE:	02/22
DRAWN BY:	THO	APPR.	JEA	
CHKD BY:	JEA	REVISION/ACTION TAKEN	RELEASED FOR BID	
PROJ. MGR:	RWD	NOT RELEASED FOR CONSTRUCTION BY	DATE	
C-104				

K:\204 Gulf Breeze and SSRUS\20410.46 Soundside STEP\DWG\C-100.dwg, Mor 09, 2022 - 2:52:57PM, toverton

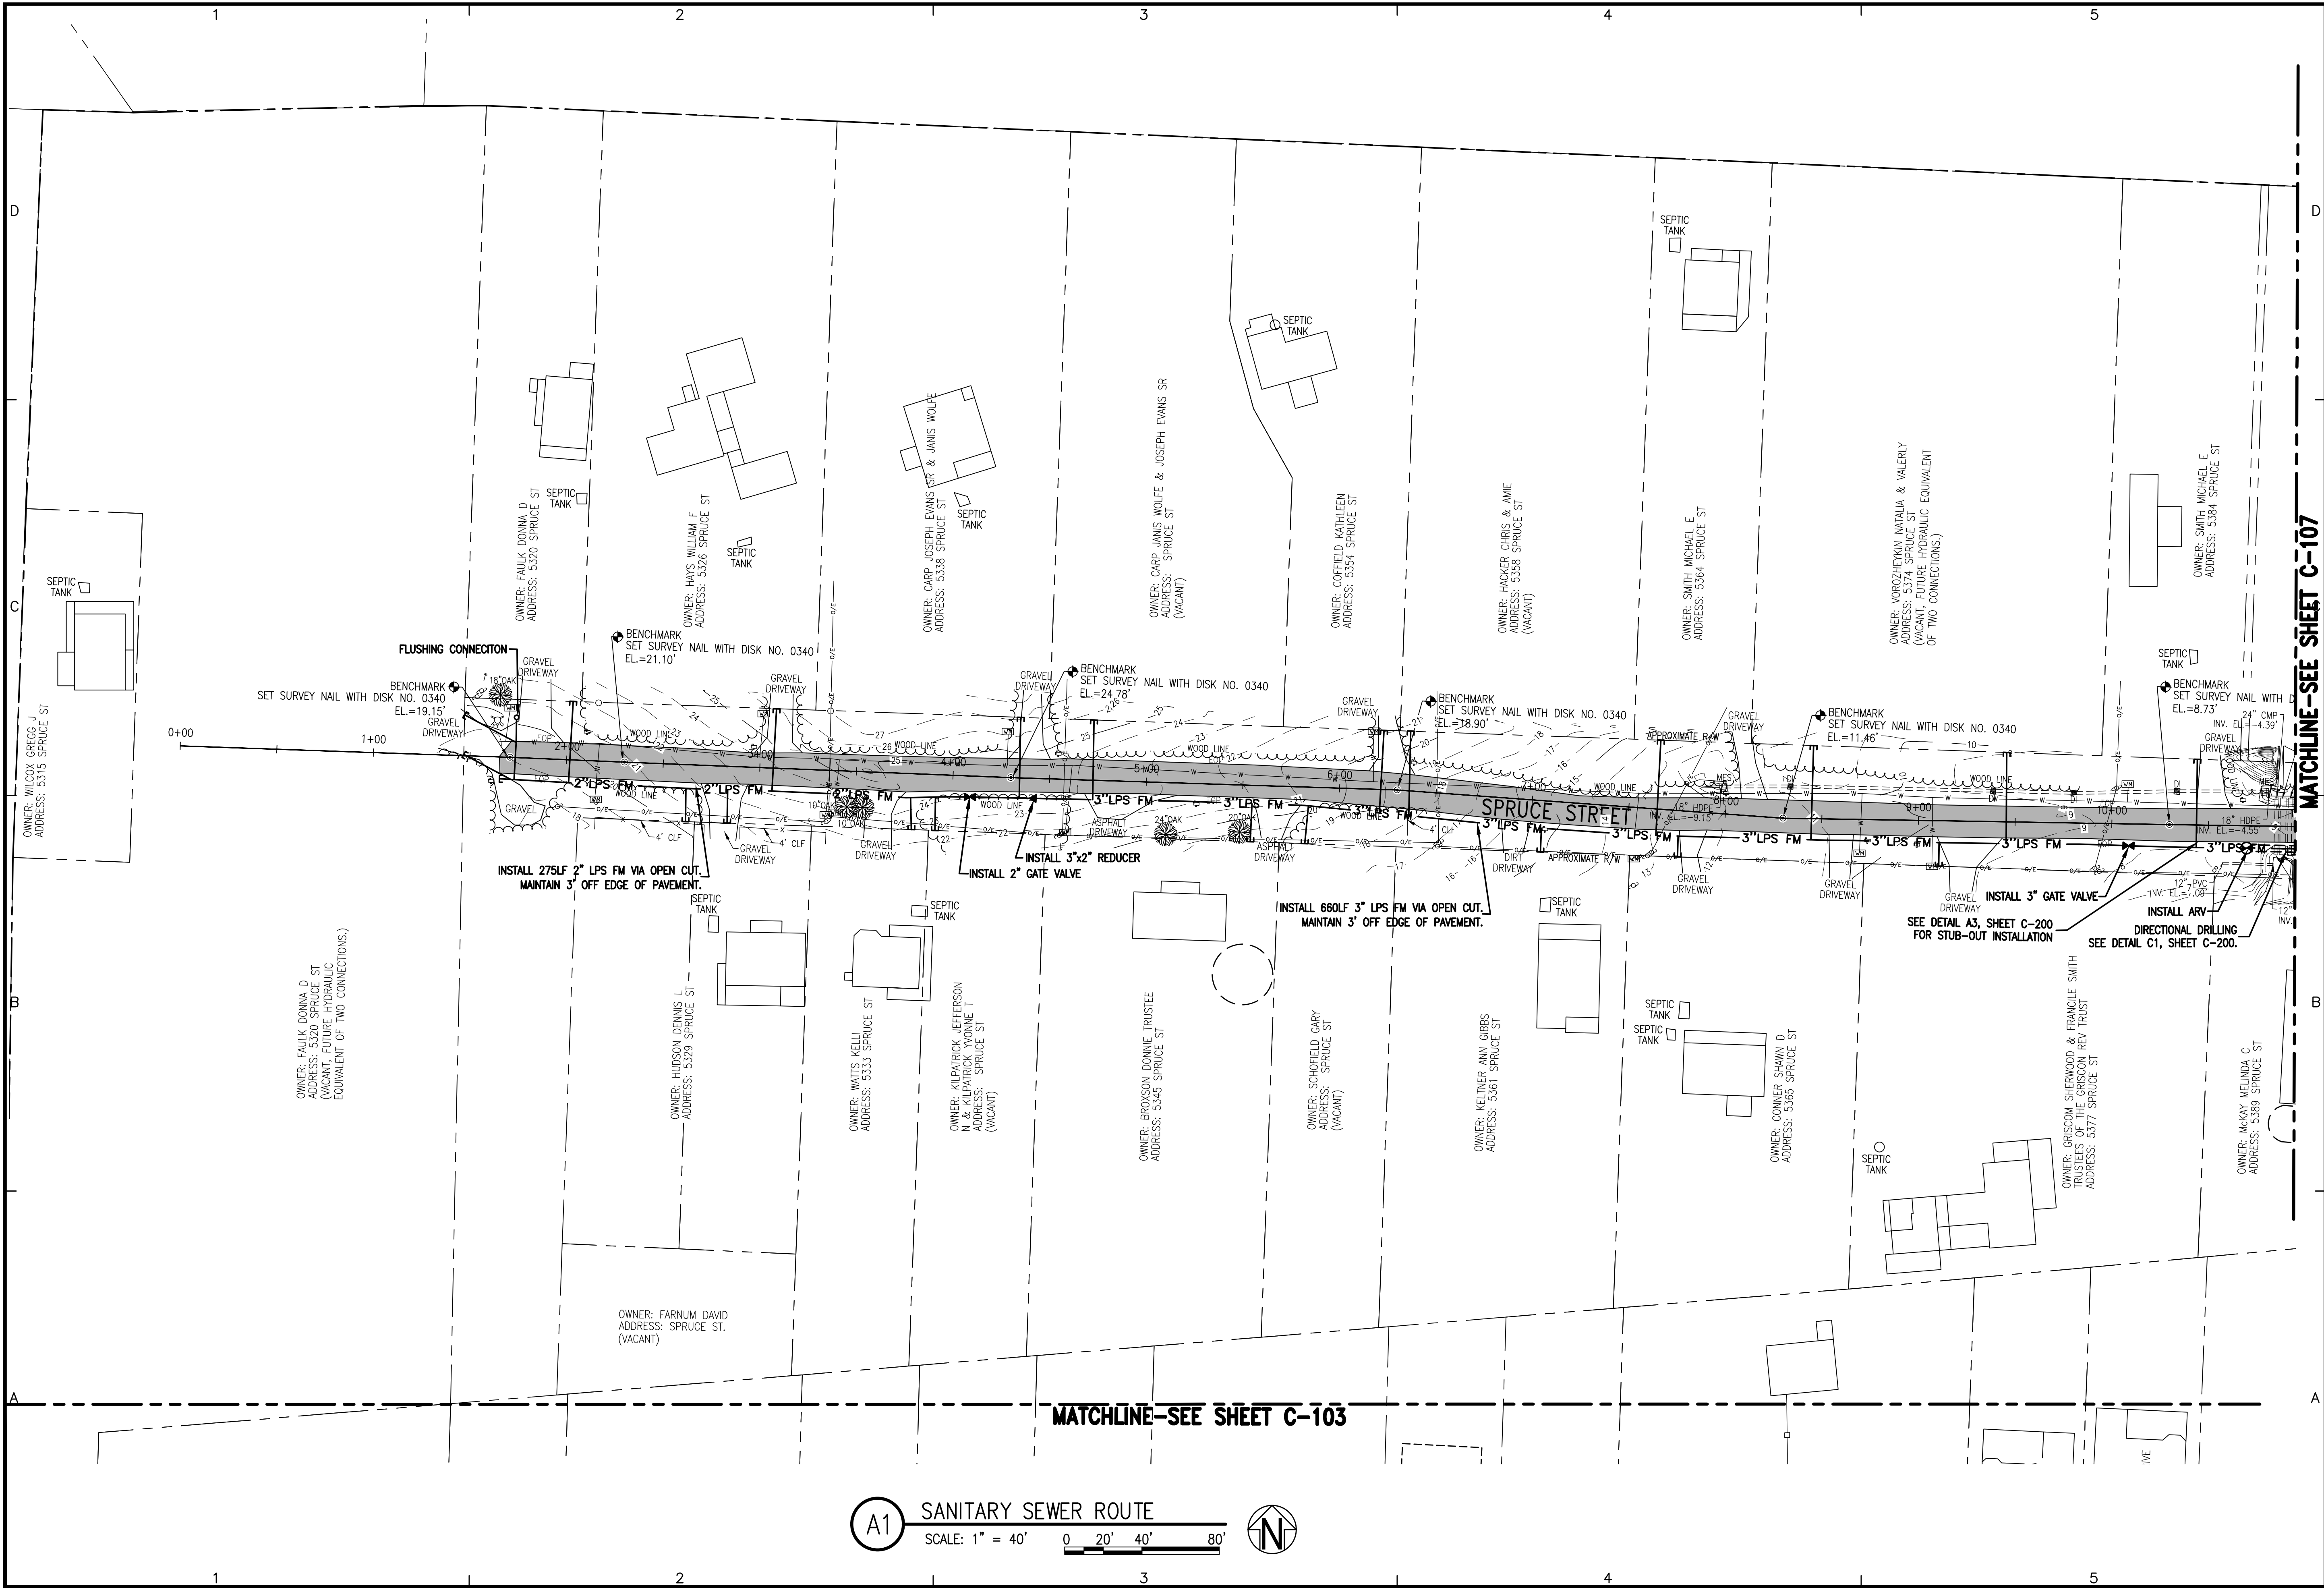


SANITARY SEWER ROUTE SOUND SIDE DRIVE	PROJECT NO. 20410.46	NO. 1	DATE 02/22	APPR. JEA	REVISION/ACTION TAKEN RELEASED FOR BID
	DESIGNED BY: KMS				
	DRAWN BY: THO				
	CHK'D BY: JEA				
C-106	PROJ. MGR: RMD				
	DATE: FEBRUARY 2022				
NOT RELEASED FOR CONSTRUCTION BY DATE					
SSRUS SOUND SIDE SEPTIC TANK ELIMINATION PROGRAM PHASE B					
SANTA ROSA COUNTY, FLORIDA					
MATCHLINE-SEE SHEET C-107					
BASKERVILLE-DONOVAN, INC. Innovative Infrastructure Solutions 449 W. MAIN ST., PENSACOLA, FL 32502 (850) 438-9861 ENGINEERING BUSINESS: EB-0000340 Pensacola - Panama City Beach - Tallahassee - Mobile This drawing is the property of BASKERVILLE-DONOVAN, INC. and is not to be reproduced in whole or in part. It is not to be used on any other project and is to be returned upon request.					

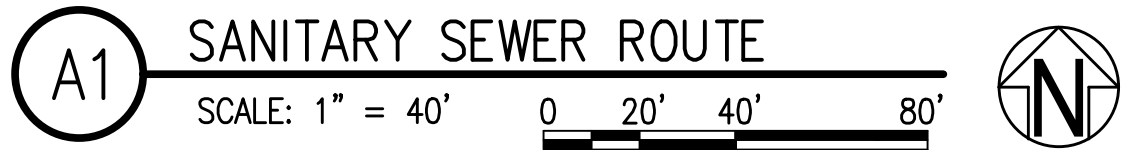

C-108 SANITARY SEWER ROUTE SPRUCE STREET	PROJECT NO:	20410.46	NO.	DATE	APPR.	REVISION/ACTION TAKEN
	DESIGNED BY:	KMS	1	02/22	JEA	RELEASED FOR BID
	DRAWN BY:	THO				
	CHK'D BY:	JEA				
	PROJ. MGR:	RWD				
DATE: PROJECT 2022		NOT RELEASED FOR CONSTRUCTION BY		DATE		
SSRUS SOUNDSIDE SEPTIC TANK ELIMINATION PROGRAM PHASE B SANTA ROSA COUNTY, FLORIDA						
BASKERVILLE-DONOVAN, INC. Innovative Infrastructure Solutions 449 W. MAIN ST. PENSACOLA, FL 32502 (850) 439-9861 ENGINEERING BUSINESS: EB-0000340 Pensacola - Panama City Beach - Tallahassee - Mobile						
This drawing is the property of BASKERVILLE-DONOVAN, INC. and is not to be reproduced in whole or in part. It is not to be used on any other project and is to be returned upon request.						
JAMES E. ANDERSON, P.E. FL Reg. Engineer #67494						

K:\204 Gulf Breeze and SSRUS\20410.46 Soundside STEP\DWG\C-200.dwg, Feb 02, 2022 - 11:43:25AM, toverton

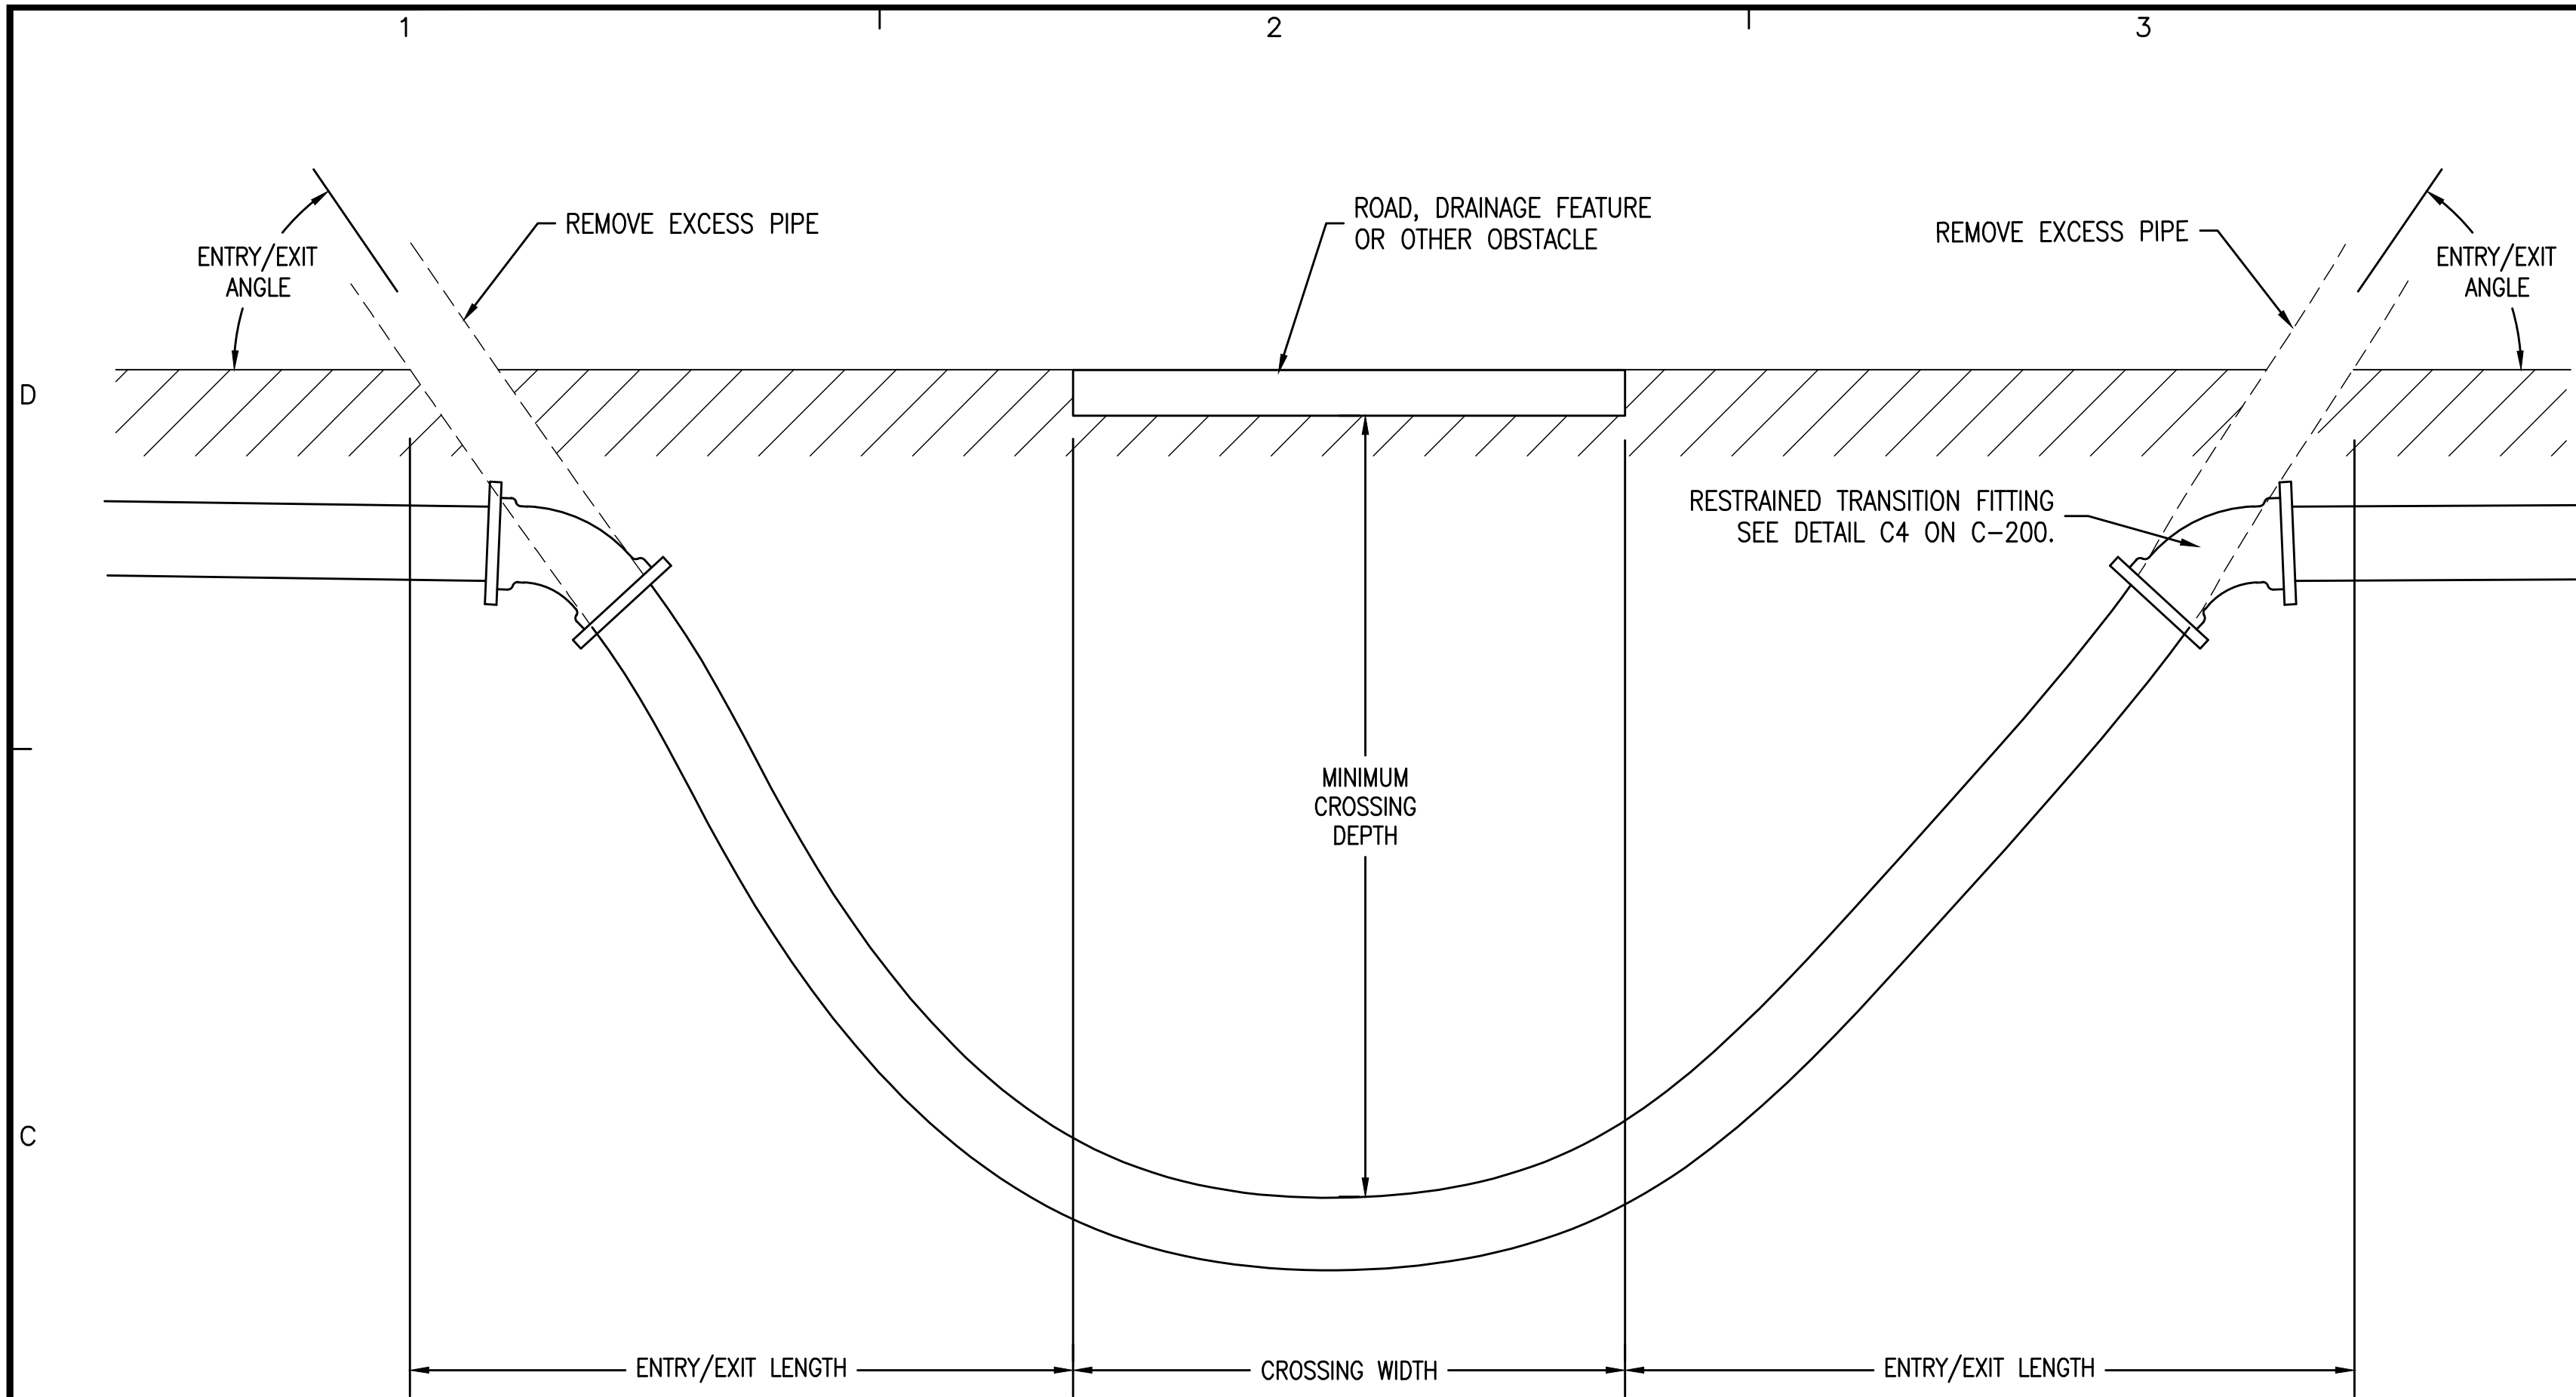


C1 TYPICAL DIRECTIONAL DRILL STANDARD DETAIL
SCALE: N.T.S.


SHEET #	ROAD NAME	APPROX. BEGIN STA	APPROX. END STA	PIPE DIA. (IN)	SERVICE	MATERIAL TYPE	DESIGN ENTRY ANGLE°	ENTRY LENGTH (FT)	DESIGN EXIT ANGLE°	EXIT LENGTH (FT)	CROSSING WIDTH (FT)	TOTAL DRILL LENGTH (FT)	MIN. CROSSING DEPTH (FT)	COMMENTS/ ADDITIONAL CONFLICT INFO
C-101	SOUNDSIDE DRIVE	10+85 RT 15'	12+10 RT 15'	3	FORCE MAIN	HDPE DR11	15	63	15	57	10	130	9	CONTRACTOR TO LOCATE AND PROTECT UTILITIES CROSSING IN SOUNDSIDE DRIVE R/W
C-104	SOUNDSIDE DRIVE AND WOODLAWN BEACH ROAD	40+13 RT 38'	40+13 LT 65'	3	FORCE MAIN	HDPE DR11	15	37	15	33	40	110	6	CONTRACTOR TO LOCATE AND PROTECT UTILITIES CROSSING IN SOUNDSIDE DRIVE AND WOODLAWN BEACH ROAD R/W
C-106	SPRUCE STREET	10+40 RT 12'	11+43 RT 12'	3	FORCE MAIN	HDPE DR11	15	43	15	47	10	100	8	CONTRACTOR TO LOCATE AND PROTECT UTILITIES CROSSING IN SPRUCE STREET R/W

NOTES:


1. LENGTHS GIVEN ARE HORIZONTAL DISTANCES AS MEASURED AT SURFACE
2. RESTRAINED TRANSITION FITTINGS SHALL BE UTILIZED FOR CONNECTION TO PIPING INSTALLED VIA OTHER METHODS
3. MINIMUM DEPTH SHALL BE CONFIRMED OR INCREASED BASED ON DRILLER'S SUBMITTED FRAC-OUT ANALYSIS AND PREVENTION PLAN
4. CONTRACTOR SHALL POSITIVELY LOCATE CONFLICTING UTILITIES AND OBSTACLES PRIOR TO BEGINNING DRILLING ACTIVITIES.
5. WHERE DIRECTIONAL DRILLS ARE INSTALLED WITHOUT AN UPSTREAM MECHANICAL ARV, CONTRACTOR TO UTILIZE MANUAL ARV FOR AIR PURGING DURING PIPE FILL.
6. ALL DIRECTIONAL DRILLS AT WATER CROSSINGS SHOULD HAVE UTILITY MARKER PLACED AT EITHER SIDE OF CROSSING.

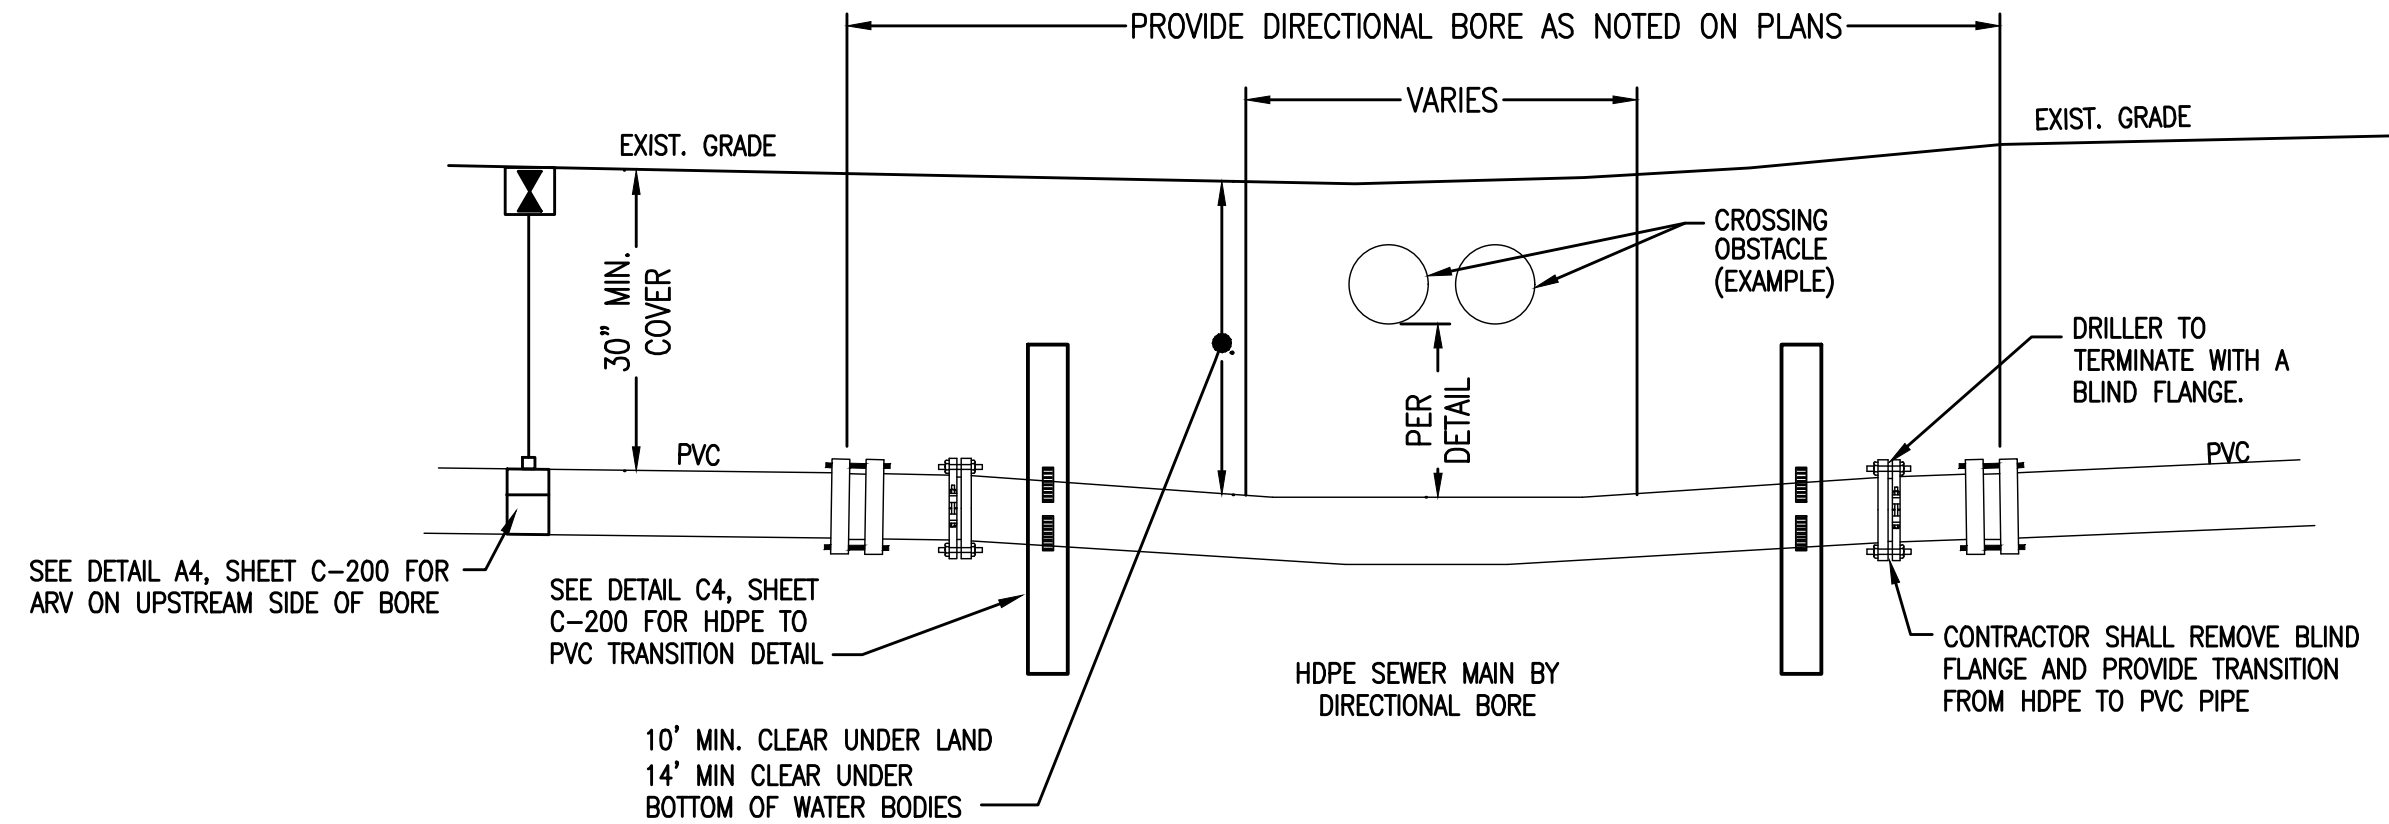


A1 DIRECTIONAL DRILL GENERAL DETAIL
NOT TO SCALE

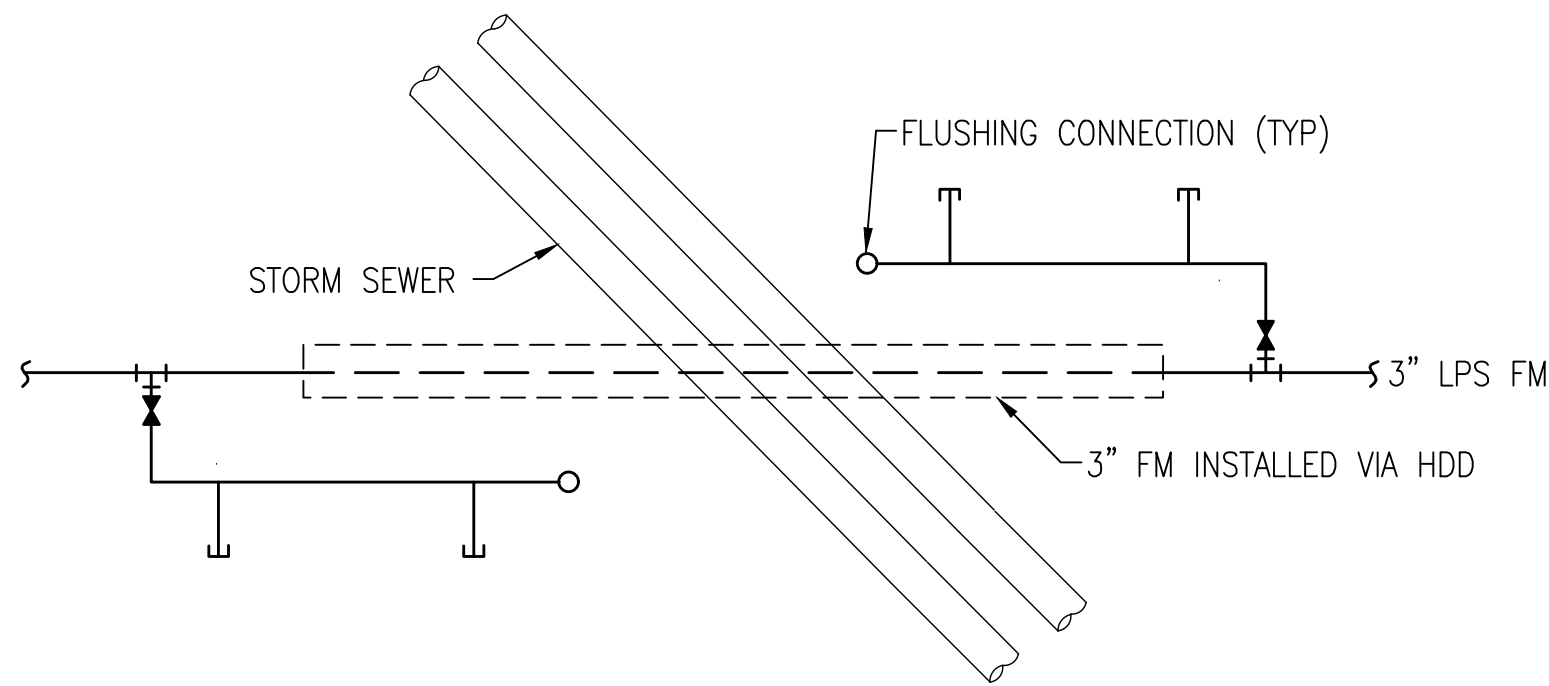

A3 SERVICE CONNECTIONS IN HDD AREAS
NOT TO SCALE

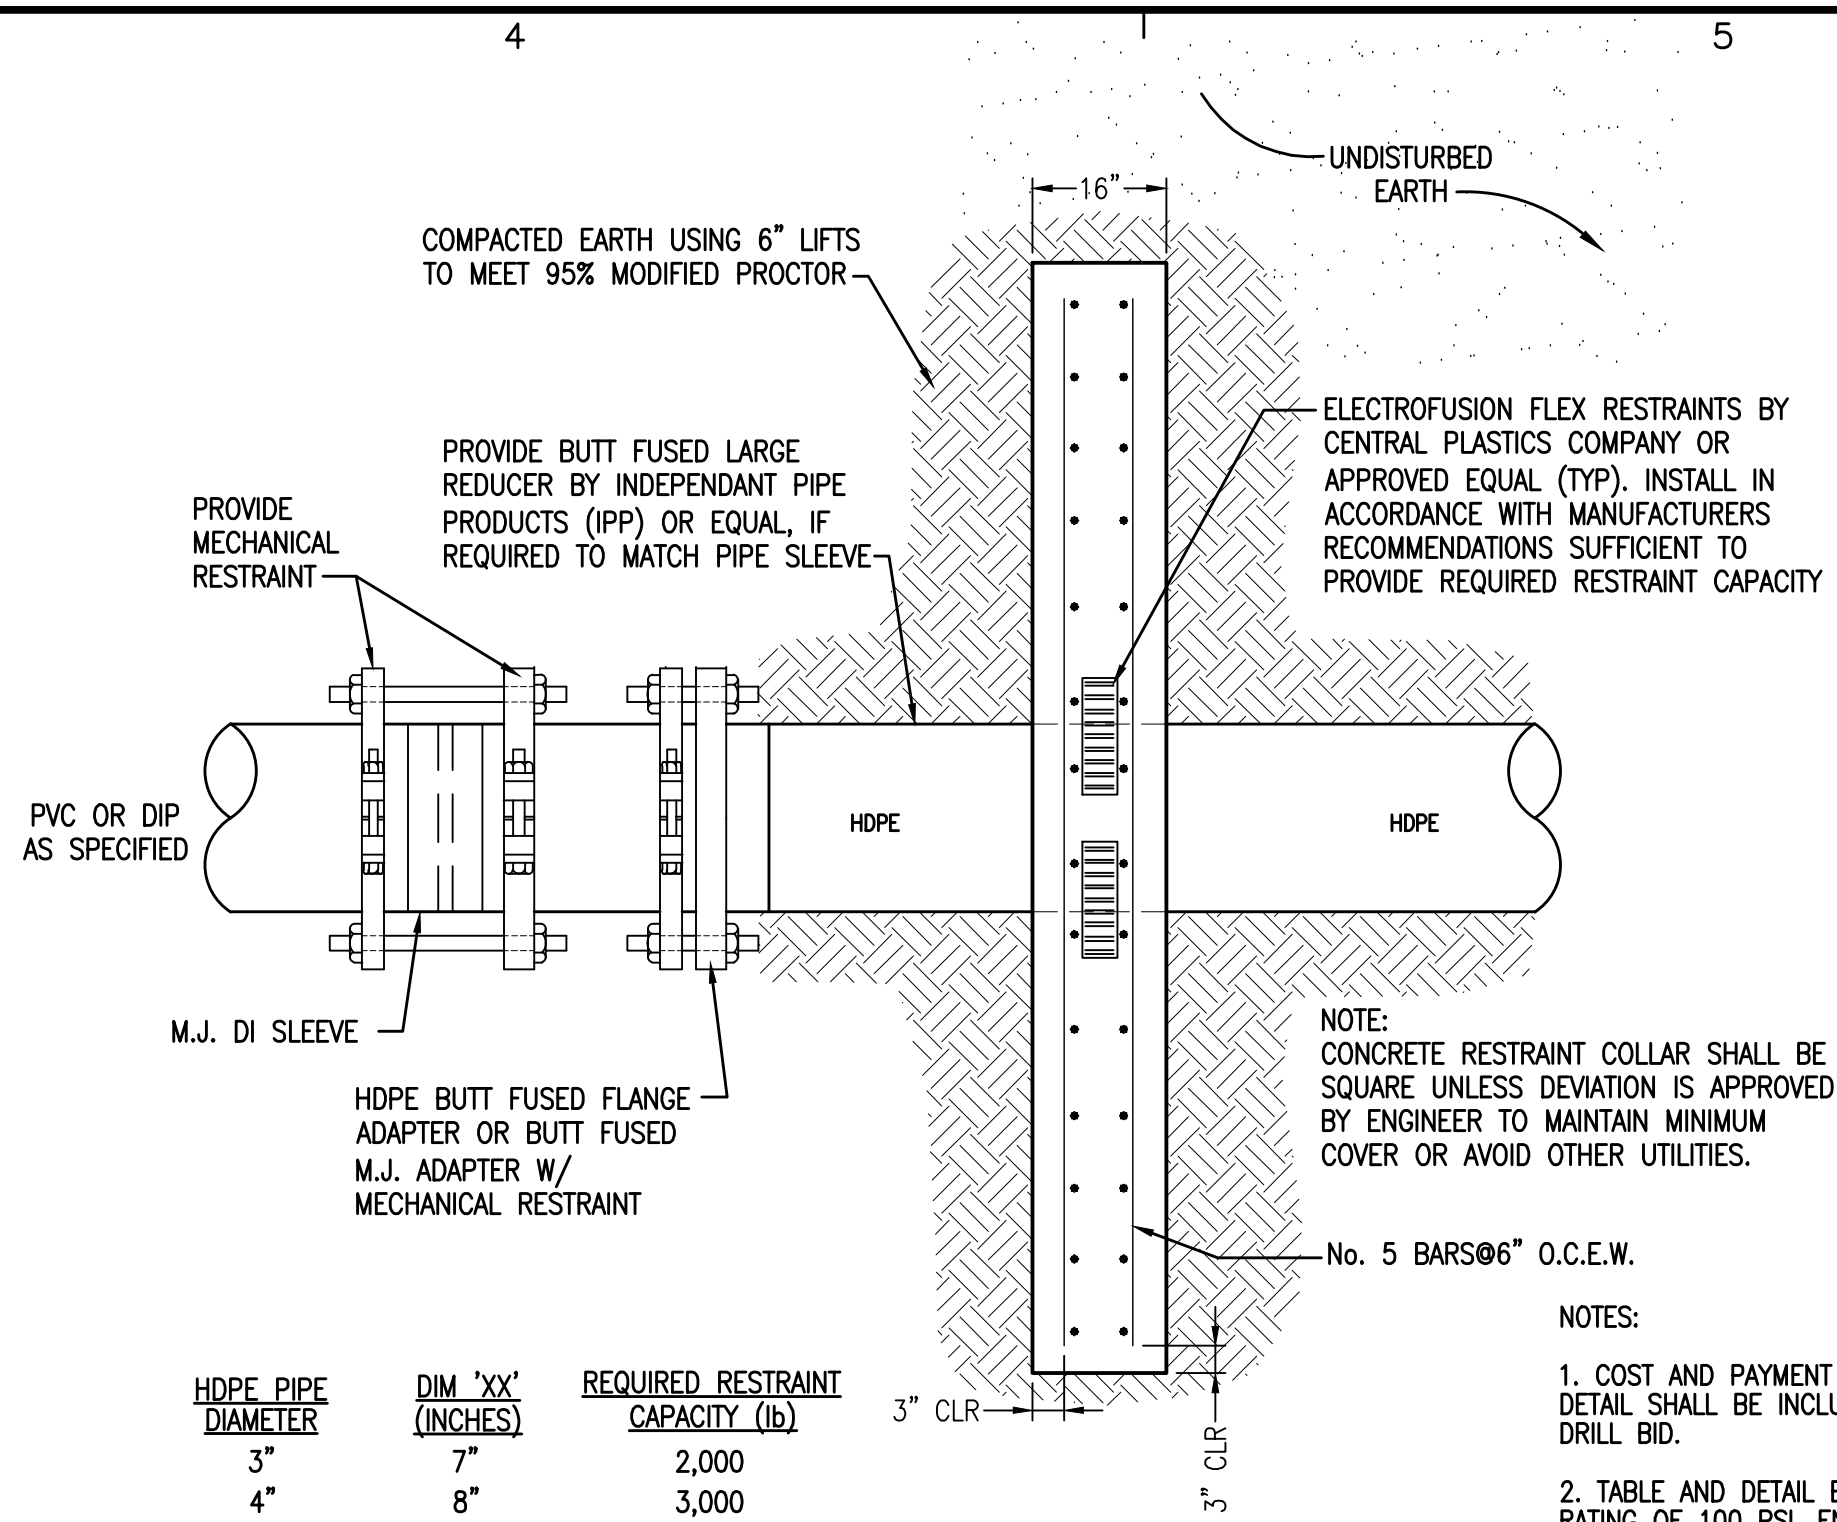

C4 PVC TO HDPE TRANSITION CONNECTION DETAIL
NOT TO SCALE

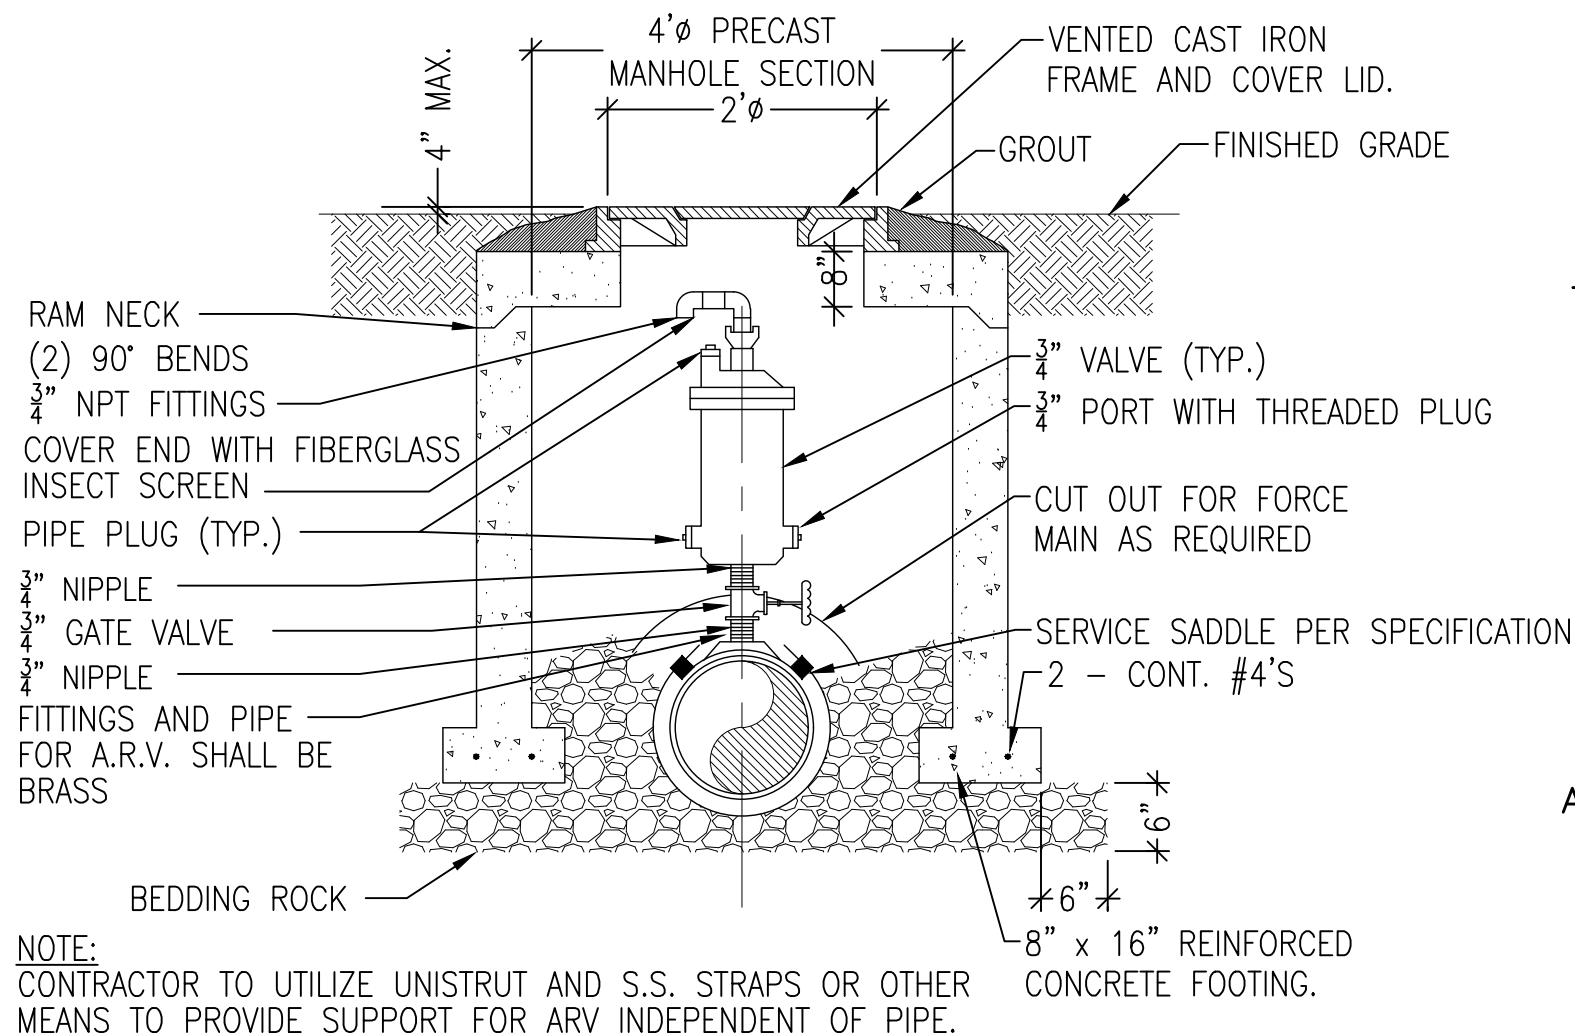

A4 AIR/VACUUM RELEASE VALVE IN MANHOLE ON SHOULDER
NOT TO SCALE

BASKERVILLE-DONOVAN, INC.
Innovative Infrastructure Solutions
22219 PANAMA CITY BEACH PARKWAY, SUITE 200, PANAMA CITY BEACH, FL 32413 (850) 230-6150
ENGINEERING BUSINESS: EB-0000340
Panama City Beach - Tallahassee - Mobile
This drawing is the property of BASKERVILLE-DONOVAN, INC. and is not to be reproduced in whole or in part. It is not to be used on any other project and is to be returned upon request.

ERIC ANDERSON
No. 67494
STATE OF FLORIDA
Professional Engineer
P.E. JAMES ERIC ANDERSON, P.E.
FL Reg. Engineer #67494

SSRUS SOUNDSIDE SEPTIC TANK ELIMINATION PROGRAM PHASE B

SANTA ROSA COUNTY, FLORIDA


PROJECT NO. 20410.46
DESIGNED BY: JEA
DRAWN BY: THO
CHK'D BY: JEA
PROJ. MGR: RMD
DATE: FEBRUARY 2022

REVISION/ACTION TAKEN
RELEASED FOR BID
NO. 1
DATE 02/22
APPR. JEA

NOT RELEASED FOR CONSTRUCTION BY DATE

DIRECTIONAL DRILL DETAIL AND SCHEDULE

C-200

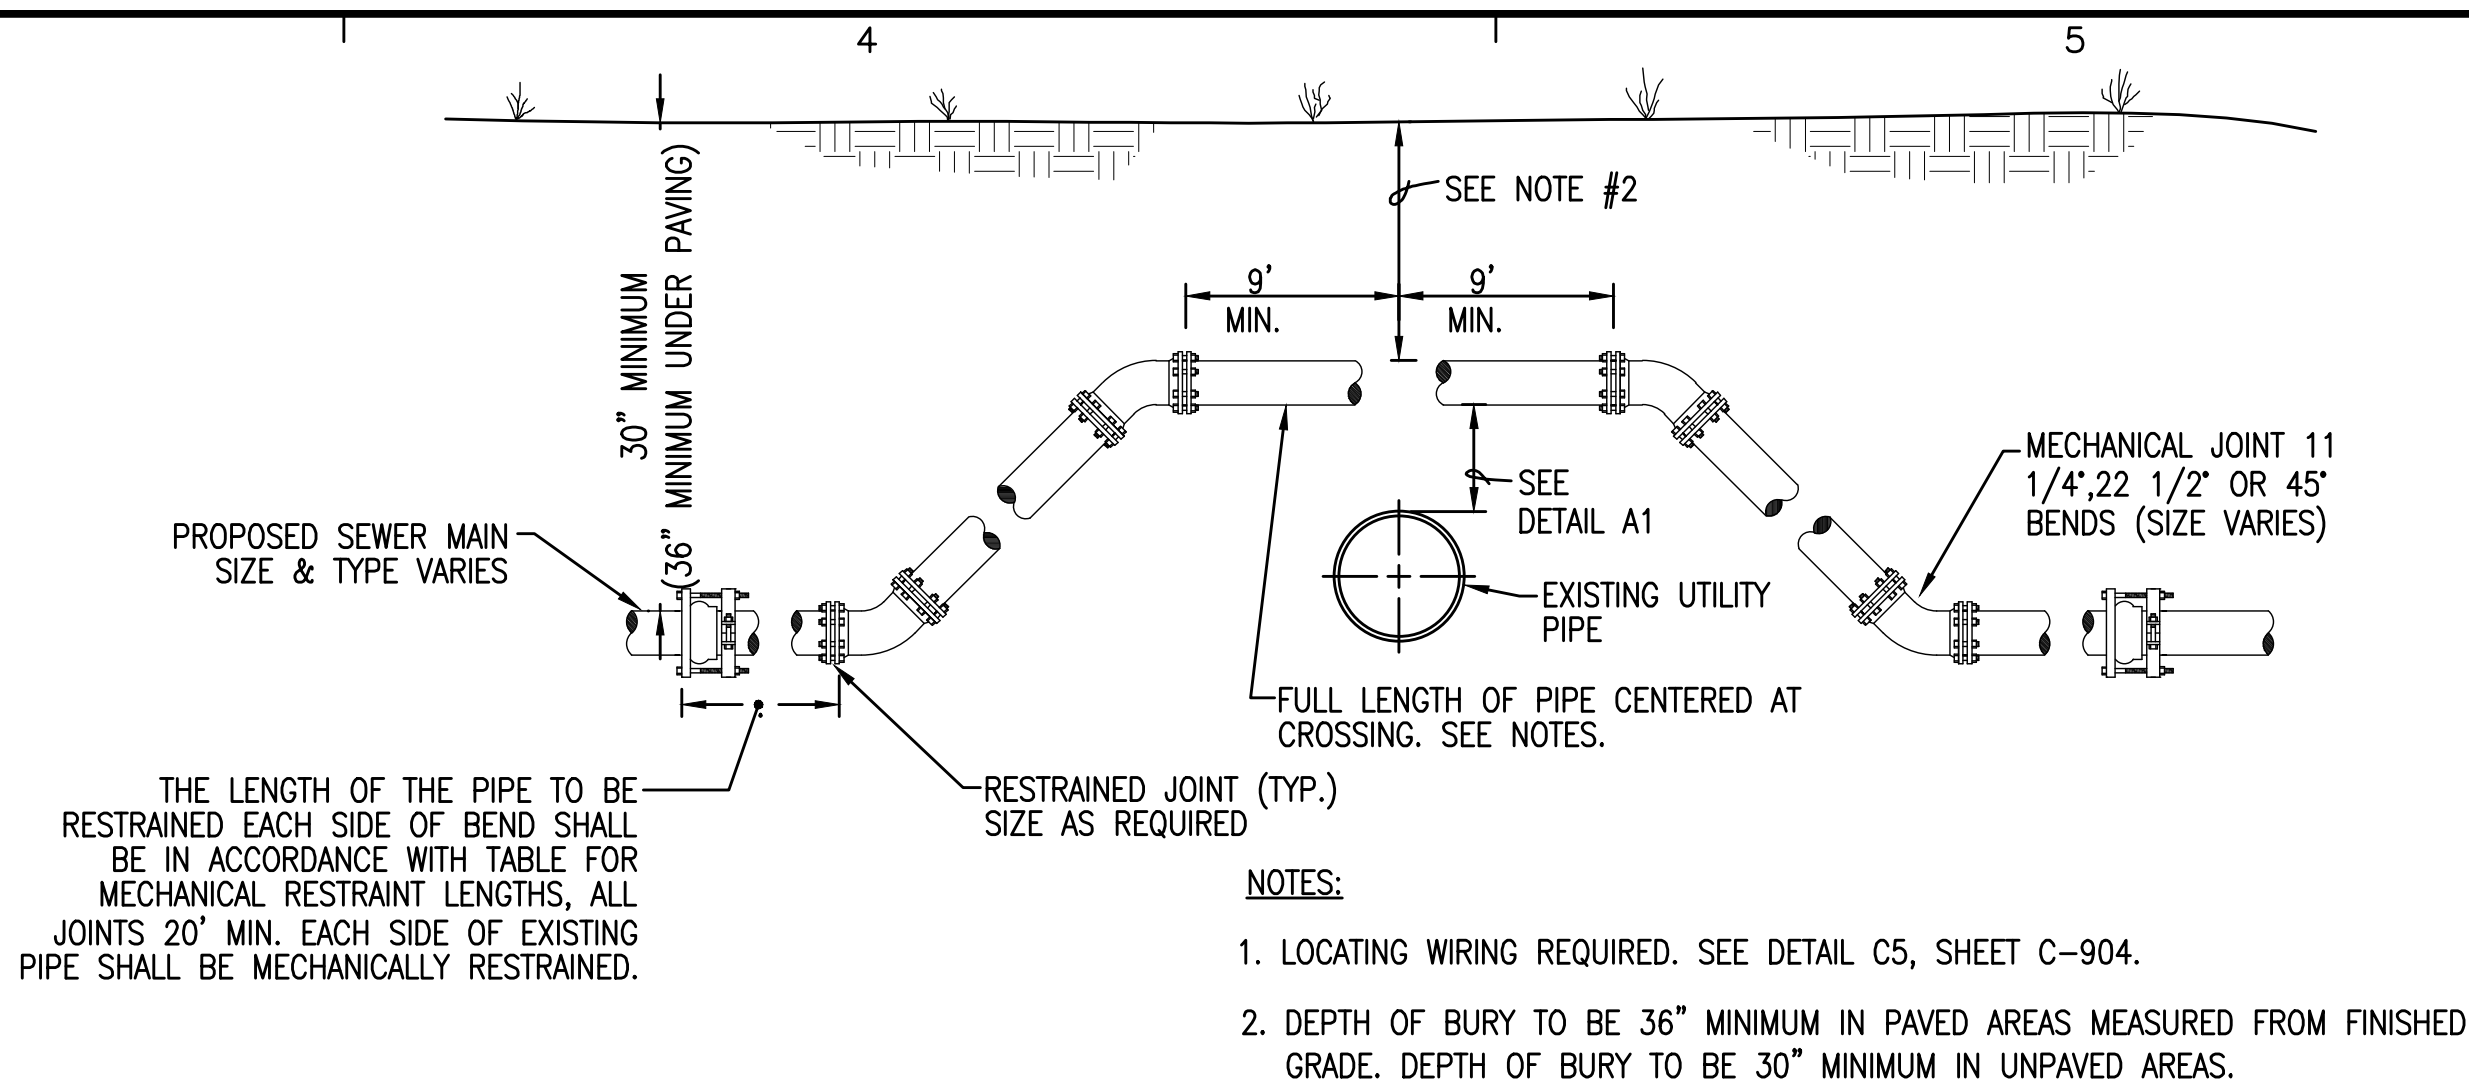

D4 ADJUSTMENT OVER EXISTING UTILITIES
NOT TO SCALE

NOTES:


1. LOCATING WIRING REQUIRED. SEE DETAIL C5, SHEET C-904.
2. DEPTH OF BURY TO BE 36" MINIMUM IN PAVED AREAS MEASURED FROM FINISHED GRADE. DEPTH OF BURY TO BE 30" MINIMUM IN UNPAVED AREAS.

EXCEPTIONS TO MINIMUM SEPARATION REQUIREMENTS

Where it is not technically feasible or economically sensible to comply with the requirements of 62-555.314(1) or (2), F.A.C., the Department shall allow exceptions to these requirements if suppliers of water or construction permit applicants provide technical or economic justification for each exception and provide alternative construction features that afford a similar level of reliability and public health protection.

LOCATION OF PUBLIC WATER SYSTEM MAINS IN ACCORDANCE WITH 62-555.314(5)(a), F.A.C.


Figure 2. Joint spacing distance Z less than required

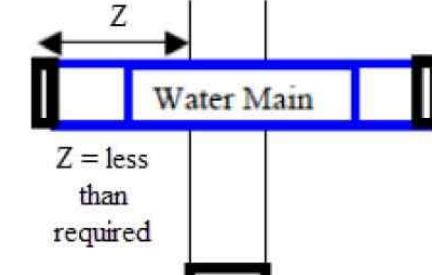

1. Use of pressure-rated pipe conforming to the American Water Works Association standards incorporated into Rule 62-555.330, F.A.C., for the other pipeline if it is a gravity- or vacuum-type pipeline;
2. Use of welded, fused, or otherwise restrained joints for either the water main or the other pipeline; or
3. Use of watertight casing pipe or concrete encasement at least four inches thick for either the water main or the other pipeline.

Figure 4. Crossing vertical separation distance Y less than required

Figure 4. Crossing vertical separation

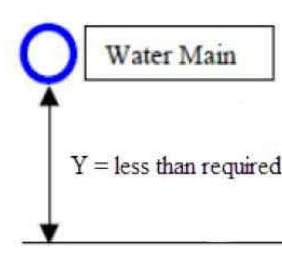

Use of pipe, or casing pipe, having high impact strength (i.e., having an impact strength at least equal to that of 0.25-inch-thick ductile iron pipe) or concrete encasement at least four inches thick for both the water main and for the other pipeline if it is new and is conveying wastewater or reclaimed water.

Refer to the next page for exceptions to the minimum separation requirements provided above.

A1 PIPE SEPARATION REQUIREMENTS

SSRUS SOUNDSIDE
SEPTIC TANK
ELIMINATION PROGRAM
PHASE B
SANTA ROSA COUNTY, FLORIDA


[illegible]

STANDARD DETAILS

C-900


K:\204 Gulf Breeze and SSRUS\20410.46 Soundside STEP\DWG\C-901.dwg, Feb 02, 2022 -- 11:45:51AM, toverton

TYPICAL PROFILE*
BELL Jt. TO PLAIN END
w/MECHANICAL RESTRAINERS

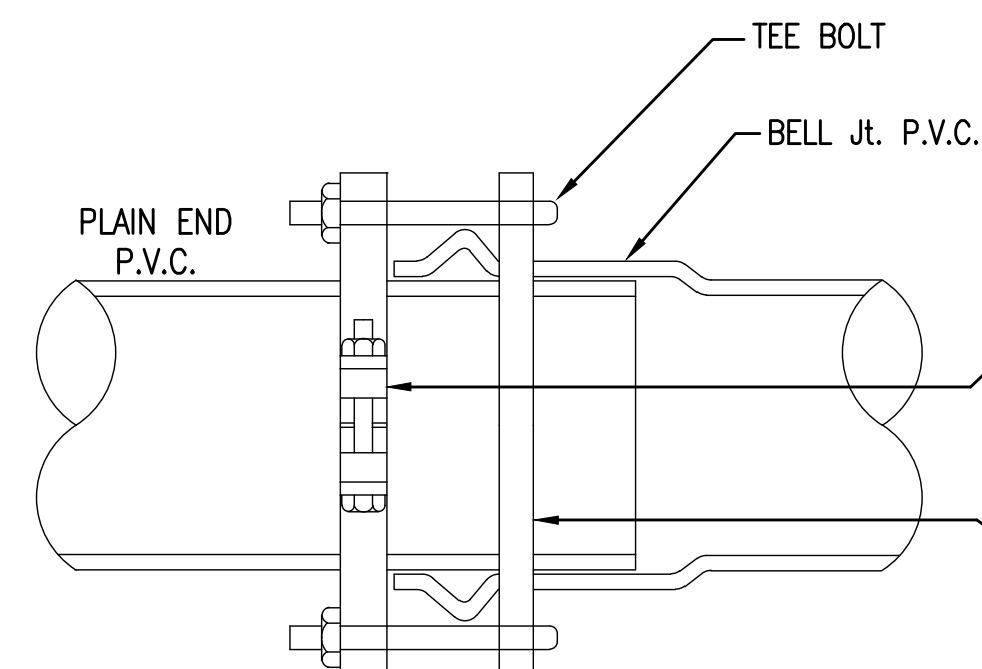


RESTRAINED BELL JOINT

TYPICAL PROFILE**
MECHANICAL Jt. TO PLAIN END
w/MECHANICAL RESTRAINERS

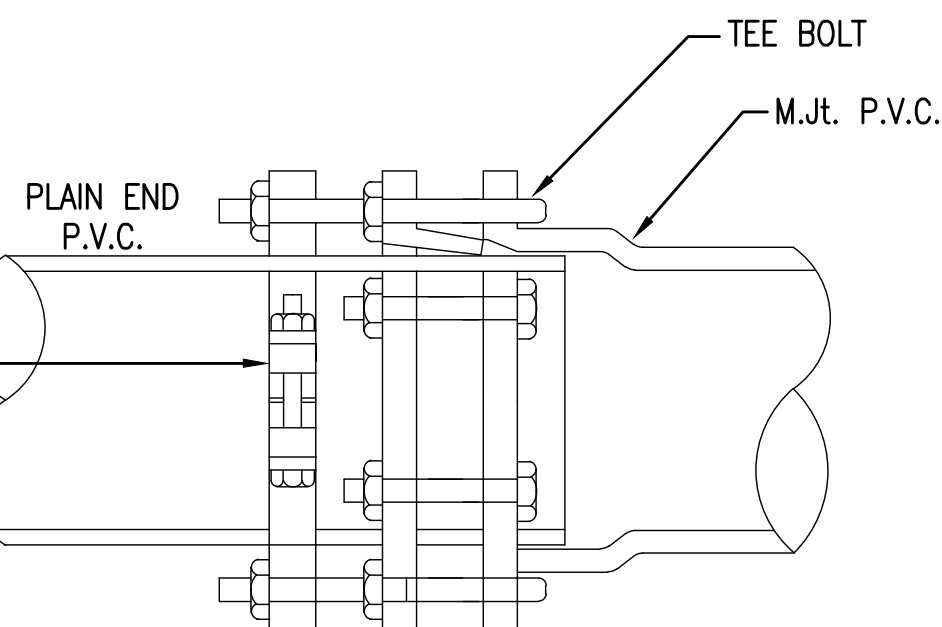


RESTRAINED MECHANICAL JOINT

SECTIONS

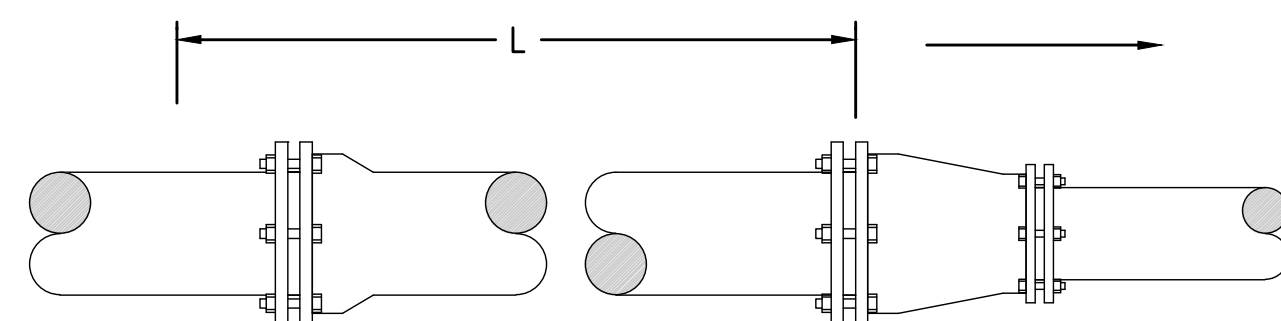


* REDUCER

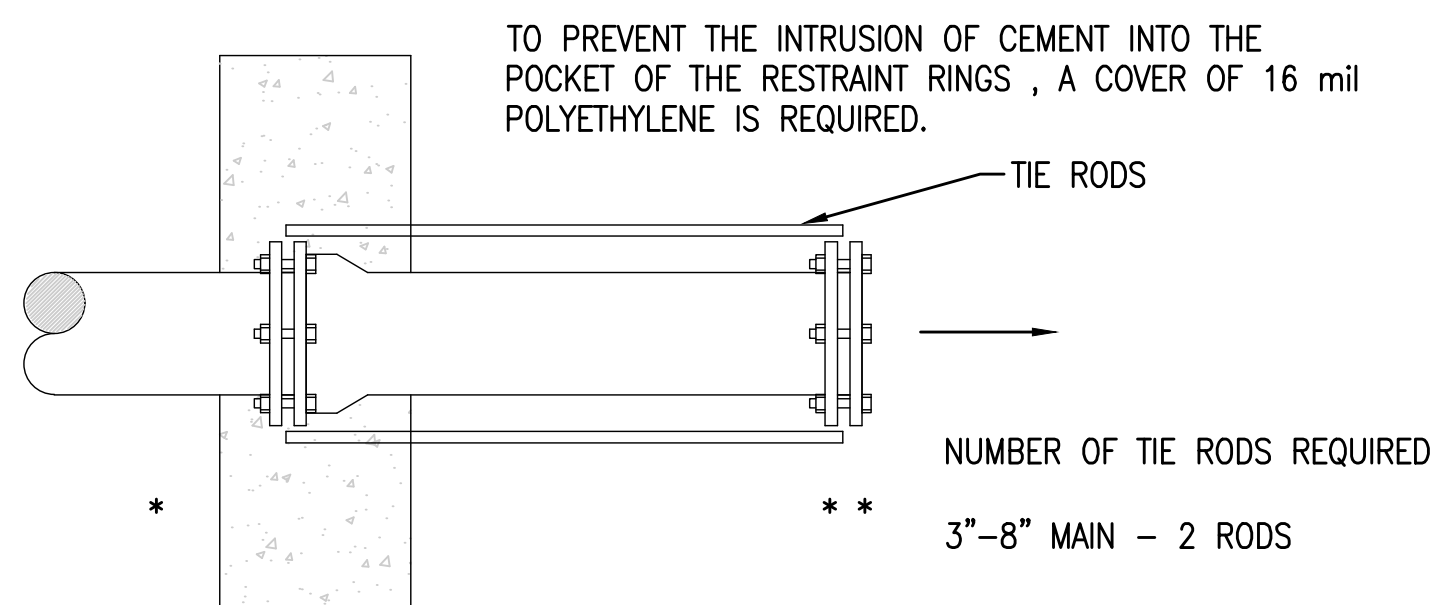

THRUST COLLAR ANCHOR
TO BE USED INSTEAD OF TOTAL
RESTRAINED LENGTH (OPTIONAL).
SIZE AS PER THRUST BLOCK DETAIL.

NUMBER OF TIE RODS REQUIRED
3"-8" MAIN - 2 RODS

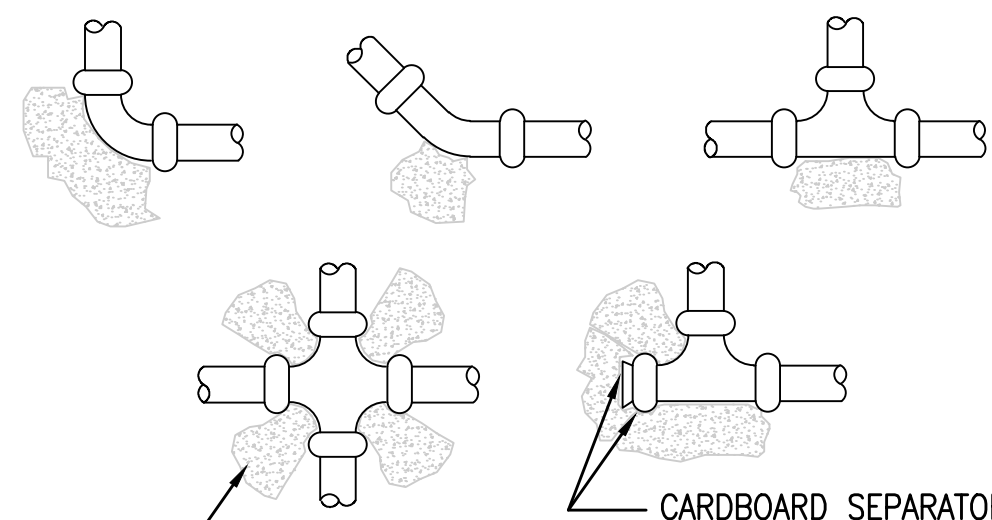

THRUST BLOCKS TO BE A MIN. THICKNESS OF 12"
W/ A THRUST AREA AS SPECIFIED IN SCHEDULE.


PIPE DIA.	CAP OR TEE	90° BEND	45° BEND	22.5° BEND
2"	1.0	1.0	1.0	1.0
3"	1.1	1.5	1.0	1.0
4"	1.9	2.7	1.4	1.0

AREAS LISTED IN SQUARE FEET

TYPE OF SOIL: SANDY SILT
BEARING CAPACITY: 1,500 PSF
PIPE PRESSURE: 150 PSI
FACTOR OF SAFETY: 1.5

A1 THRUST BLOCK SUPPORT DETAIL

NOT TO SCALE

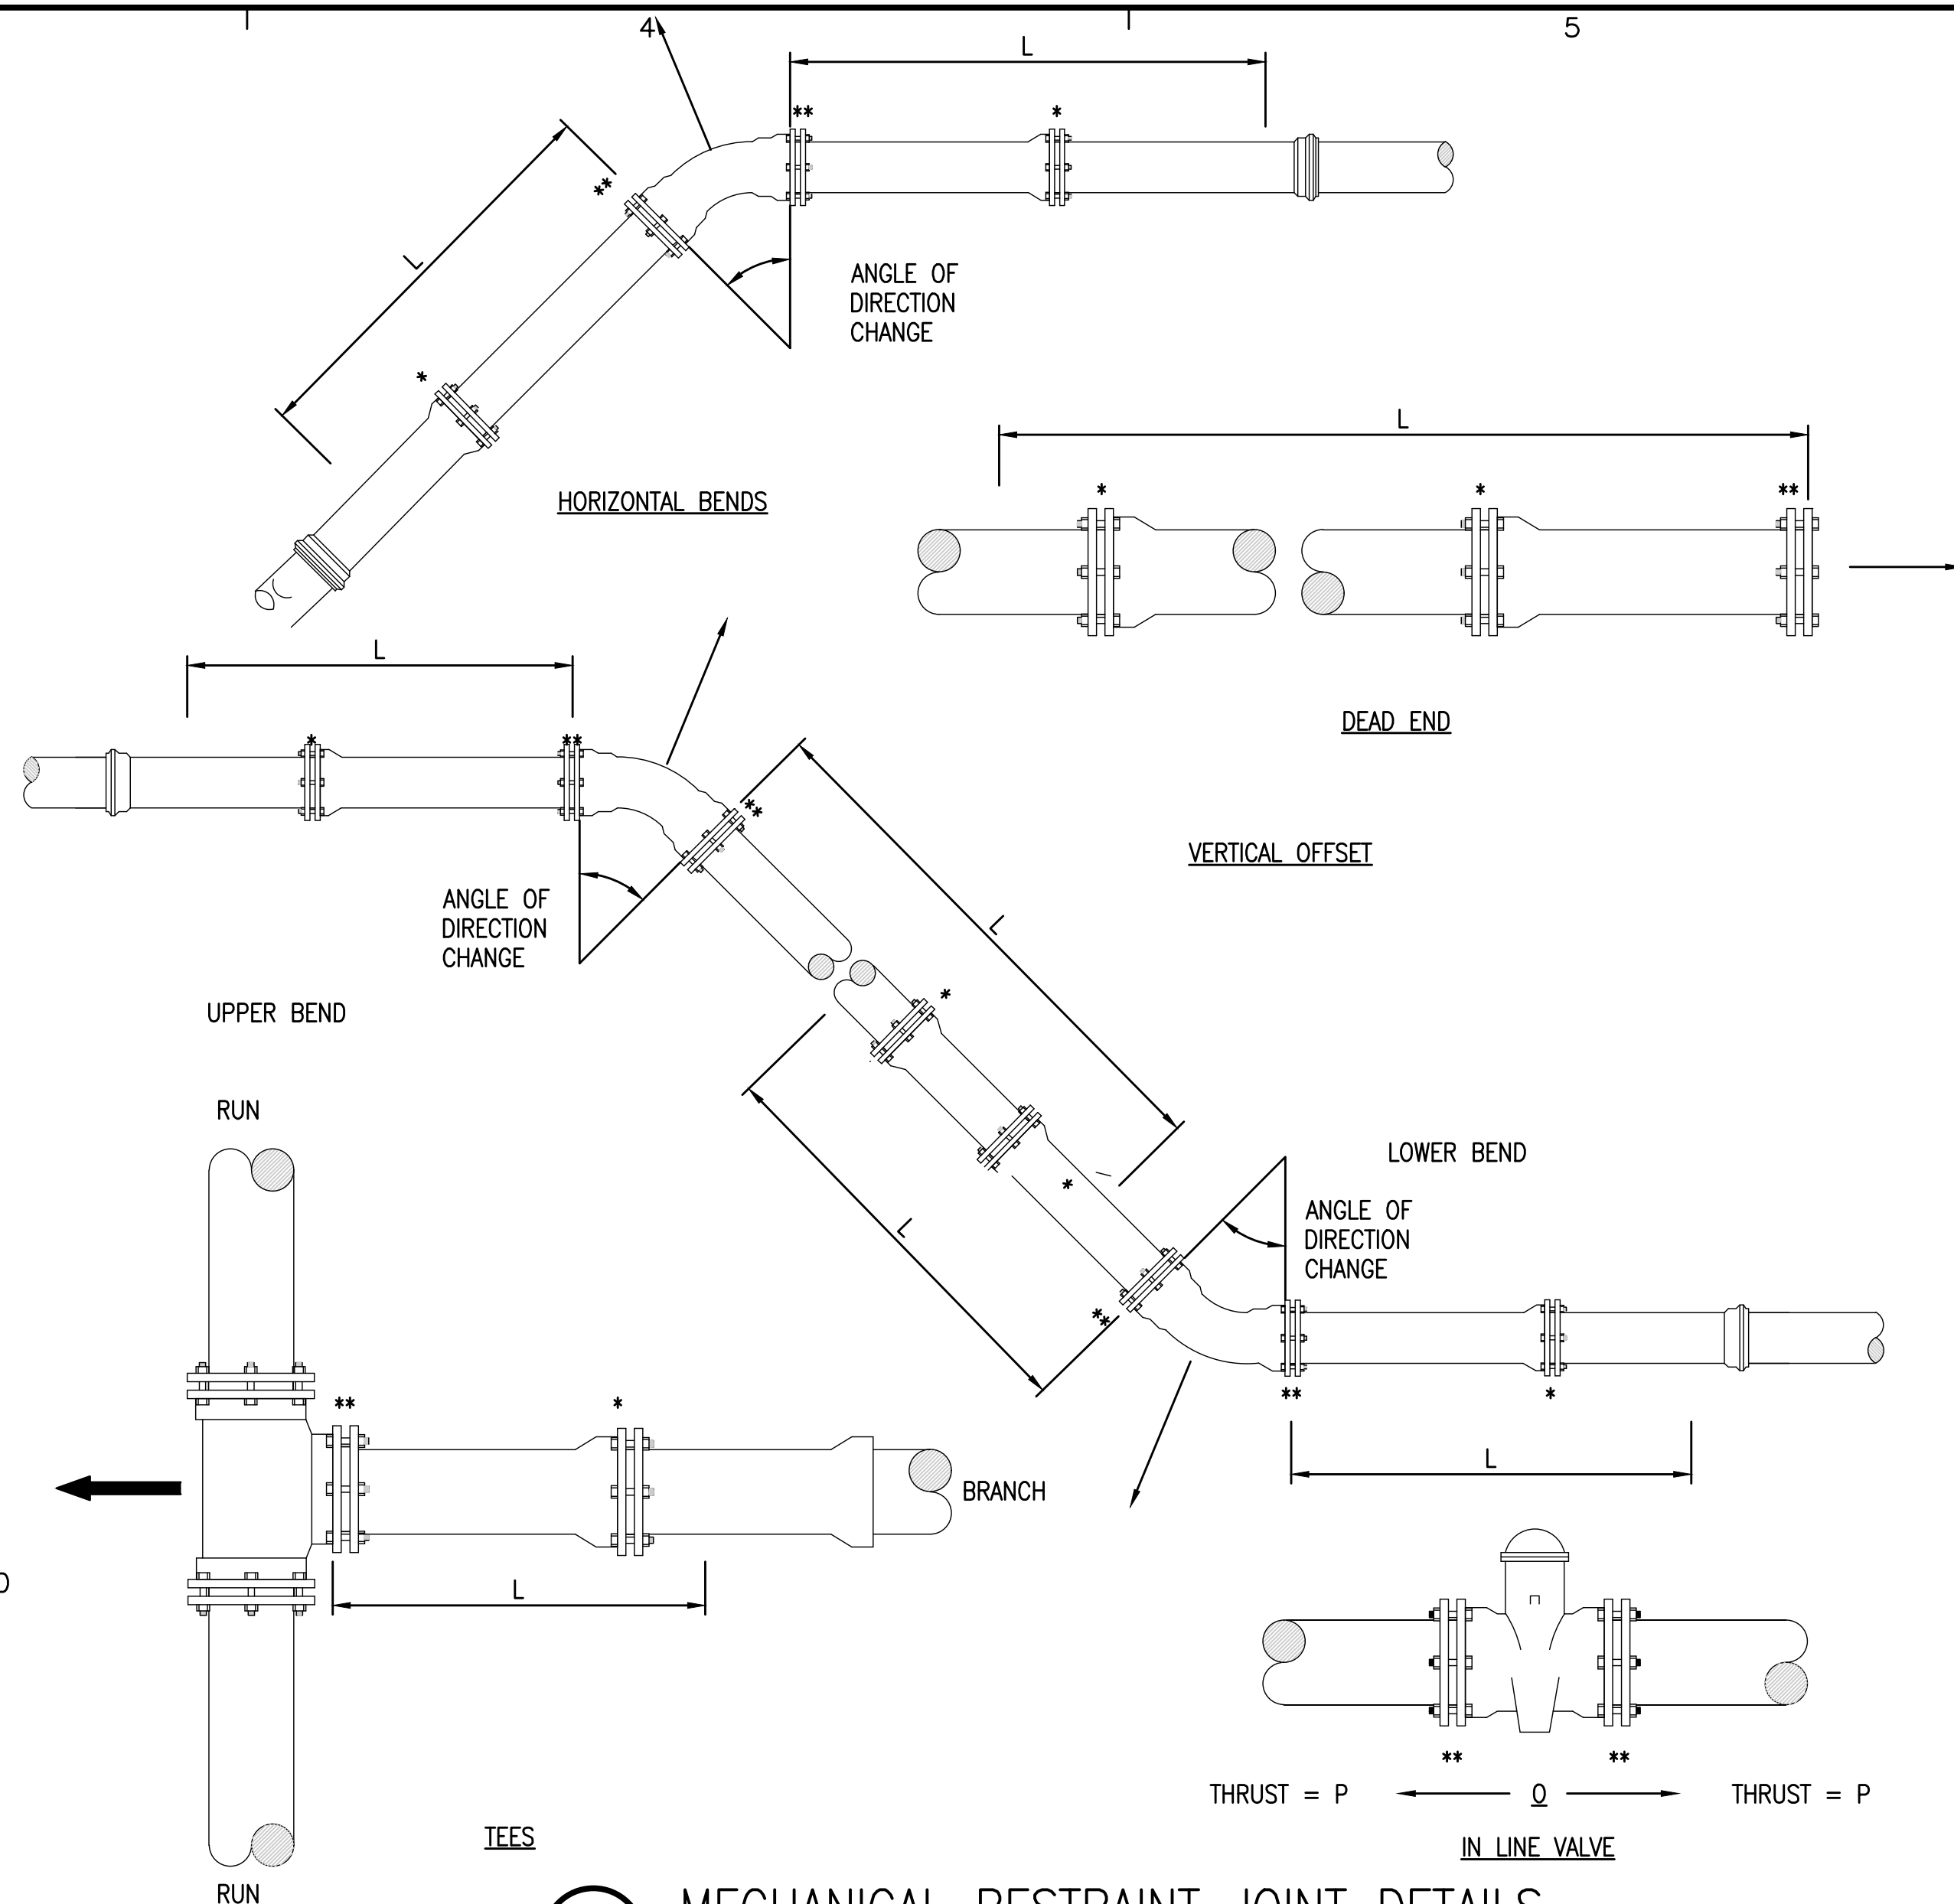

B4 MECHANICAL RESTRAINT JOINT DETAILS

NOT TO SCALE

L=MINIMUM LENGTH TO BE RESTRAINED ON EACH SIDE OF FITTING (FEET)

NOMINAL PIPE SIZE (INCHES)	11 1/4" HORIZONTAL ELBOW	22 1/2" HORIZONTAL ELBOW	45" HORIZONTAL ELBOW	90" HORIZONTAL ELBOW	20 - RUN	1 - BRANCH	HORIZONTAL PLUGS & VALVES (SEE NOTE 3)	45° VERTICAL OFFSET UPPER LENGTH	45° VERTICAL OFFSET LOWER LENGTH	22 1/2° VERT. OFFSET UPPER LENGTH	22 1/2° VERT. OFFSET LOWER LENGTH	REDUCER TO 1 SIZE SMALLER LENGTH ON LARGER SIZE SIDE
≤ 4	2	4	7	18			39	16 / 3		8 / 1		13


NOTES

- TABLE ASSUMPTIONS: PVC PIPE, SAFETY FACTOR = 1.5, TEST PRESSURE = 150PSI, SOIL = GM OR SM, 3 FT. BURY DEPTH TO TOP OF PIPE, TRENCH TYPE 3, BRANCH ON TEE IS EQUAL SIZE OR SMALLER THAN RUN OF TEE SIZE AND 20 FEET OF PIPE IS INSTALLED PAST THE TEE ON THE RUN SIDE (SMALLER BRANCH SIZES MUST BE CALCULATED BY THE ENGINEER). VERTICAL OFFSETS ARE 3 FEET DEEP ON TOP AND 8 FEET DEEP ON BOTTOM. REDUCERS ARE CALCULATED FOR ONE SIZE REDUCTION. OTHER CONDITIONS WILL REQUIRE ADDITIONAL CALCULATIONS.
- ALL FITTINGS MUST BE RESTRAINED. ONE OF THE FOLLOWING METHODS MAY BE USED:
A. MECHANICAL RESTRAINTS AT FITTING AND AT ADJACENT JOINTS TO A LENGTH AS SPECIFIED IN CHART.
B. TIE RODS AT FITTING AND THROUGH JOINTS TO A LENGTH AS SPECIFIED IN CHART.


A4 MECHANICAL RESTRAINT LENGTH TABLE - PVC

NOT TO SCALE


K:\204 Gulf Breeze and SSRUS\20410.46 Soundside STEP\DWG\C-902.dwg, Mar 09, 2022 - 2:29:42PM, toverton

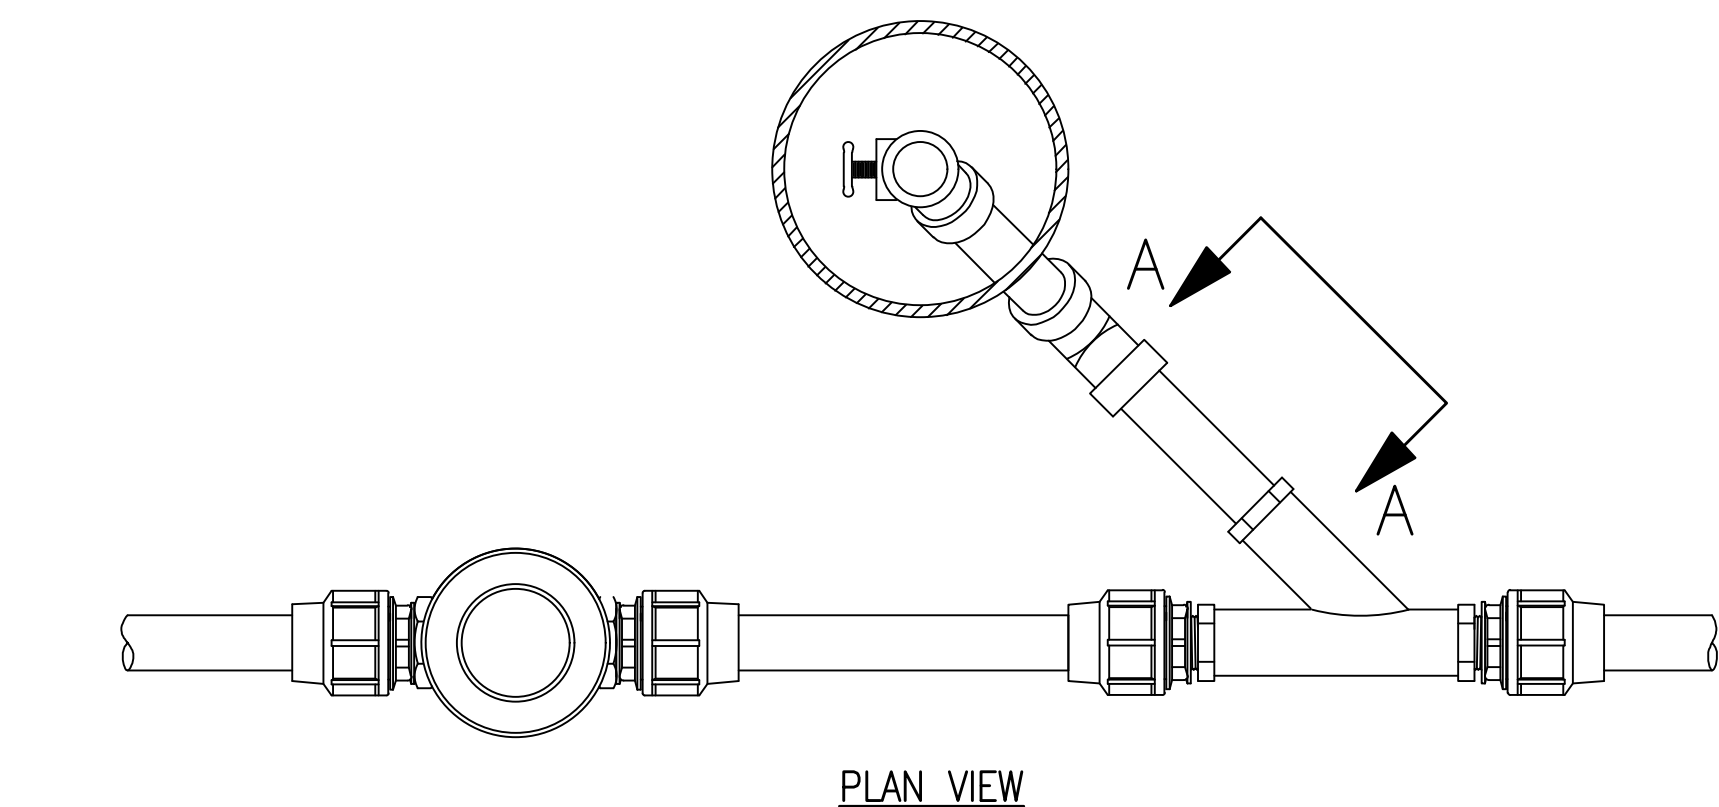

C1 TYPICAL FLUSHING CONNECTION ON LPSS MAIN
NOT TO SCALE

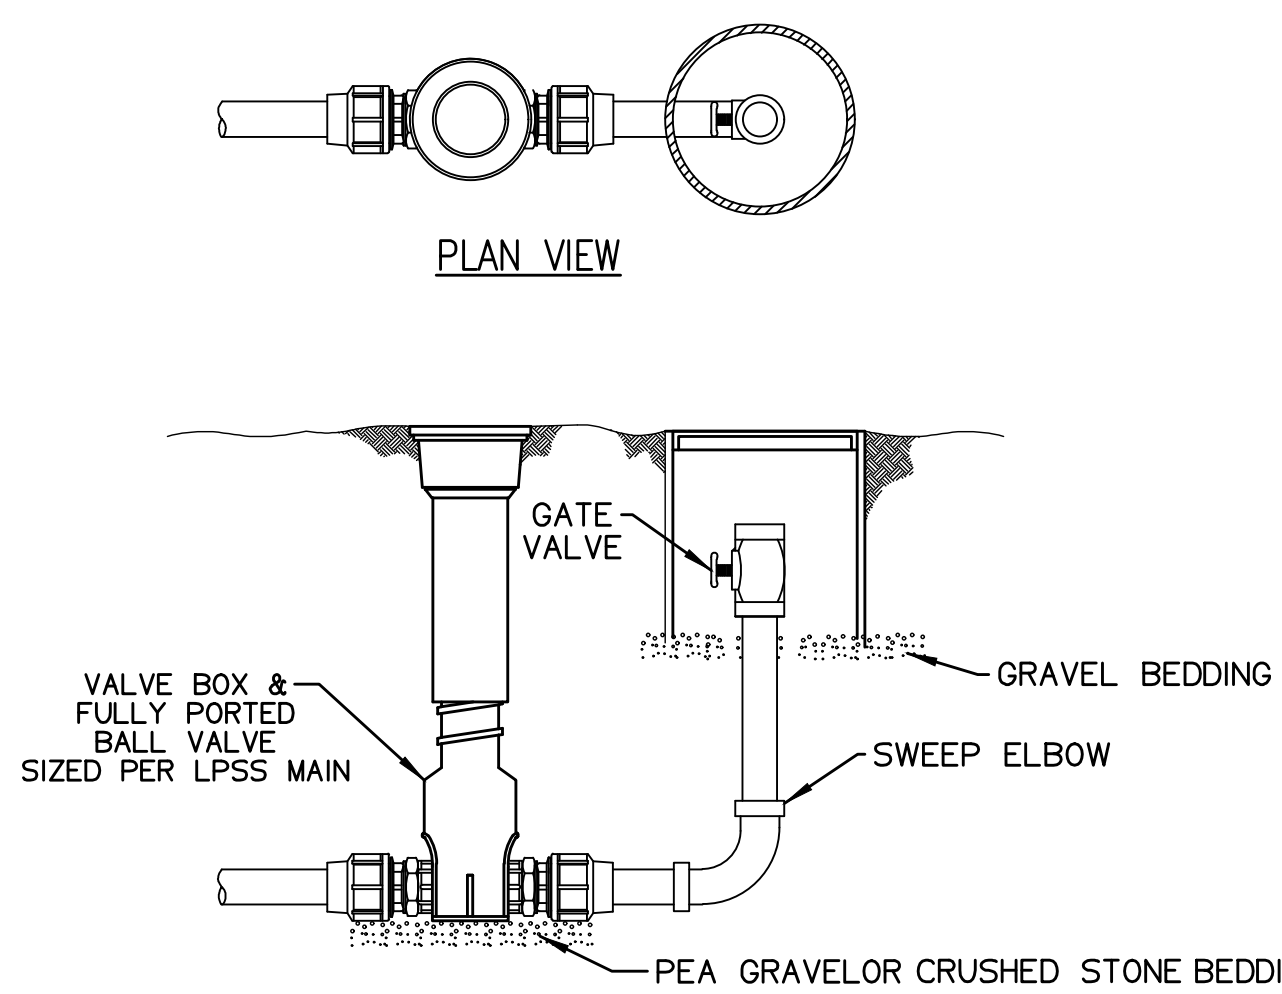


A1 TYPICAL TERMINAL FLUSHING CONNECTION
NOT TO SCALE

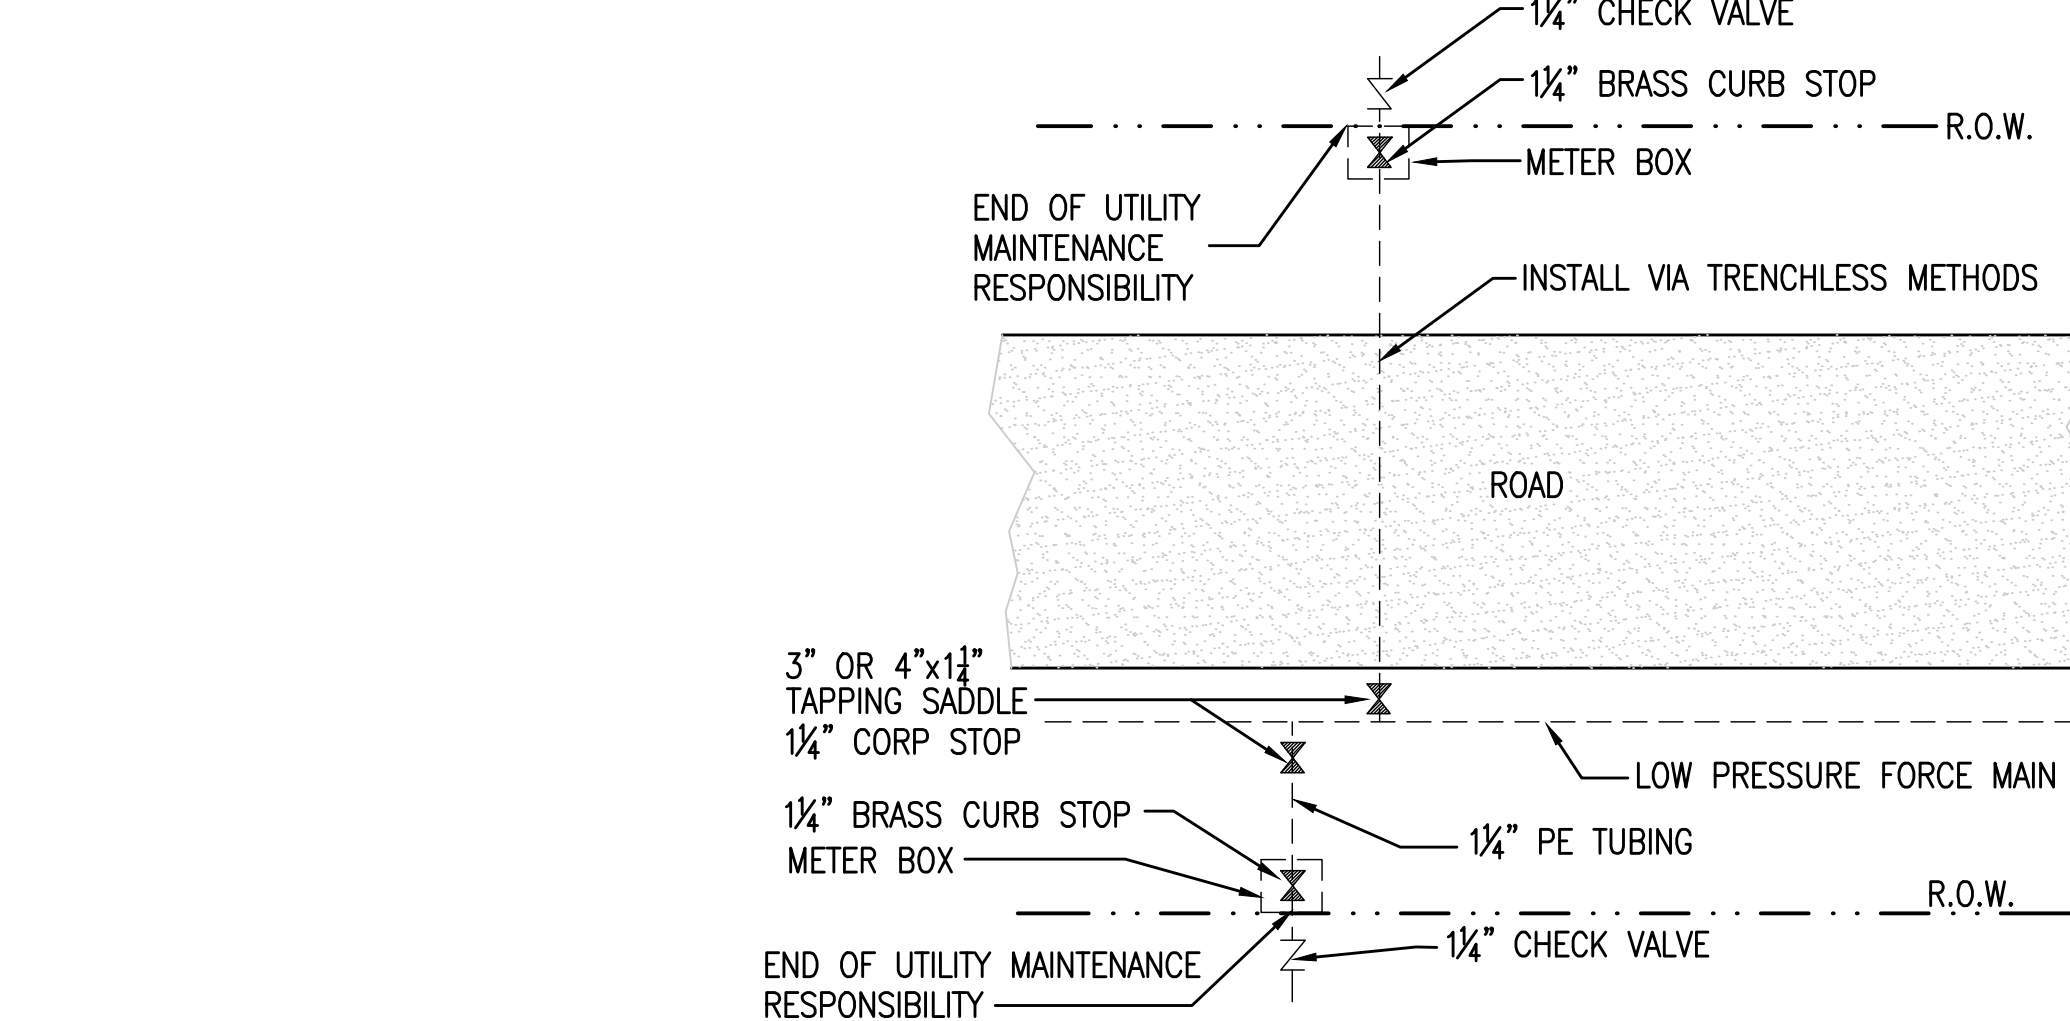


D3 TYPICAL LONG & SHORT SERVICE
NOT TO SCALE

NOTE:

SEE DETAIL A2 AND A4 BELOW FOR PROFILE VIEW OF LONG AND SHORT SERVICE CONNECTION.

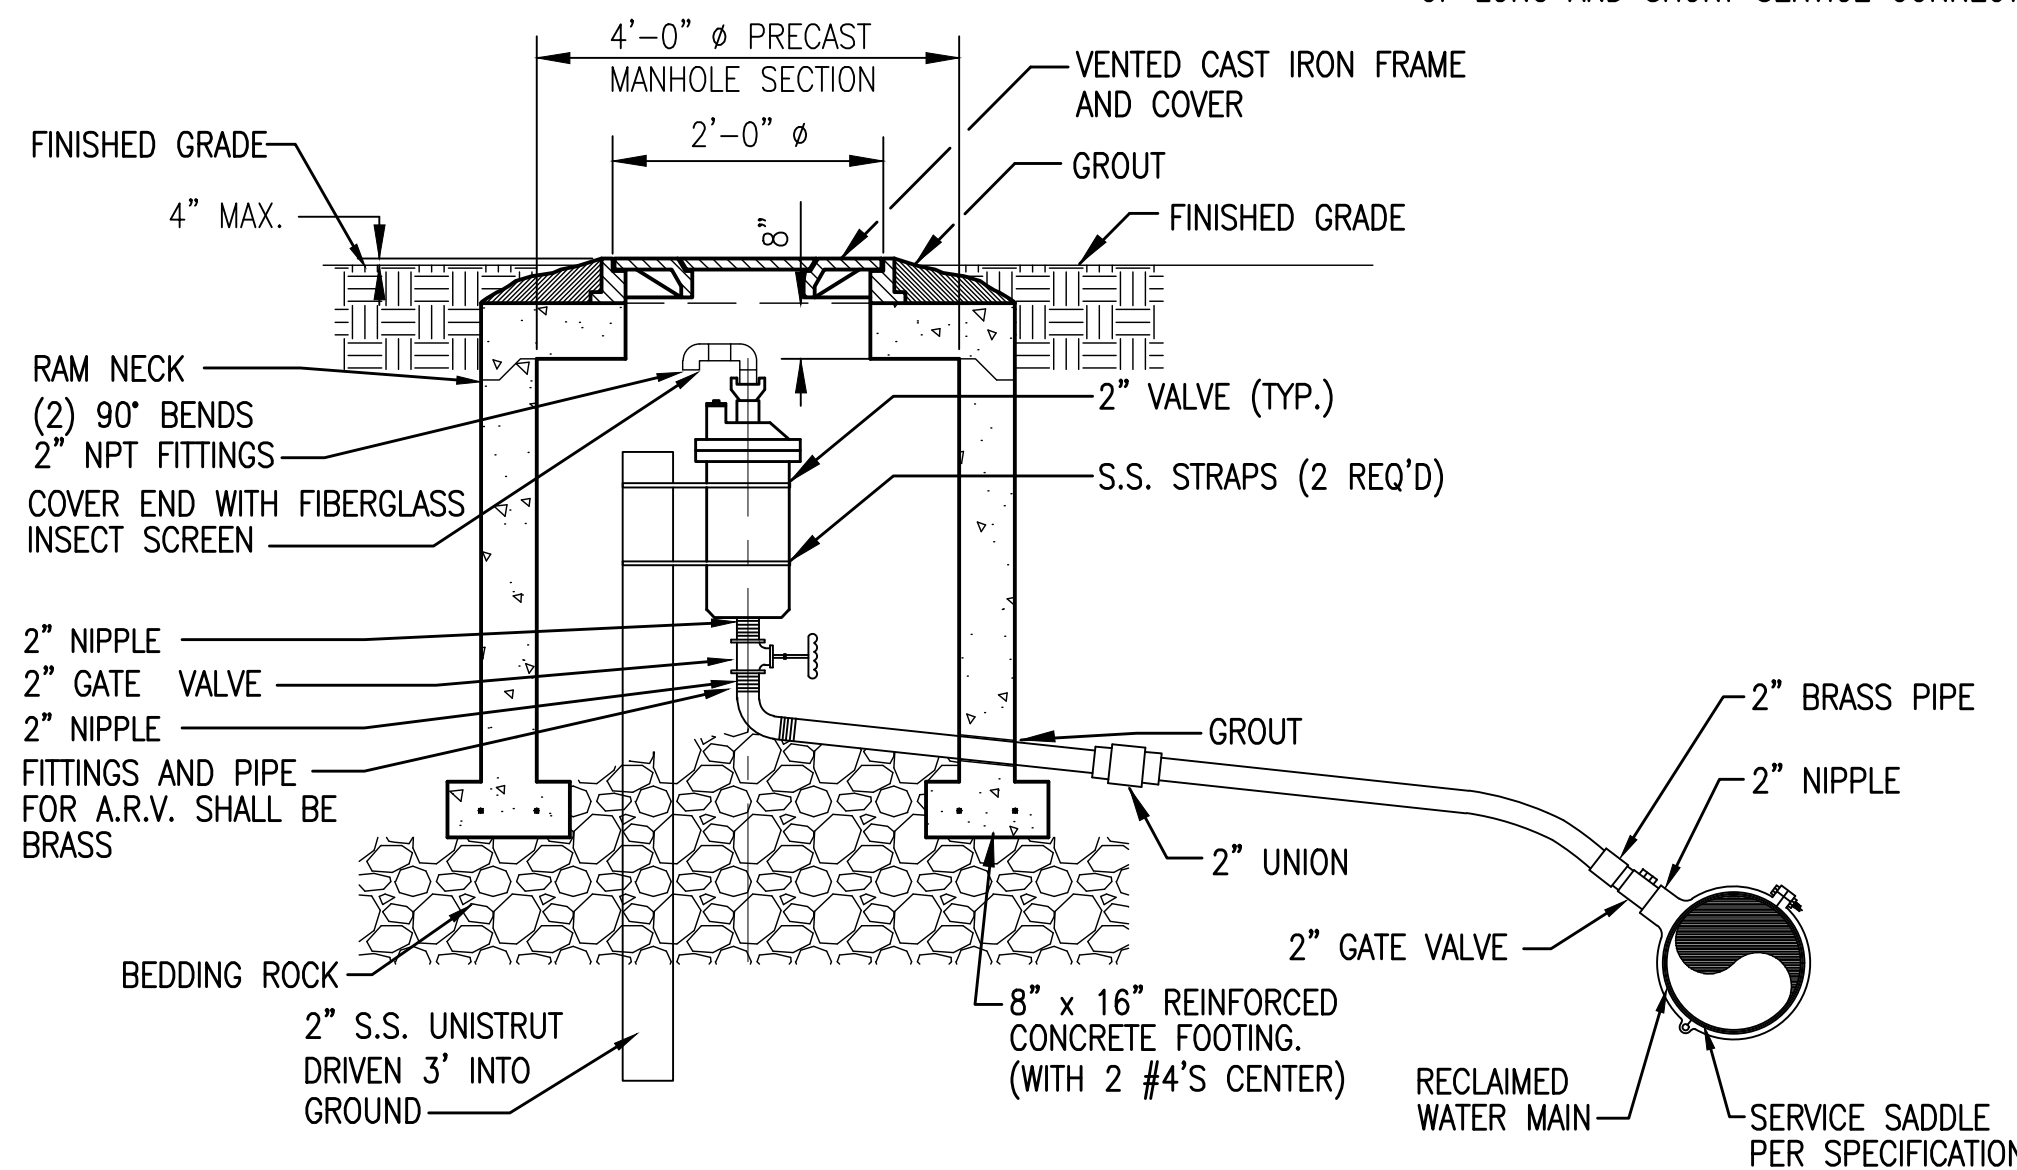


B3 OFFSET AIR/VACUUM RELEASE VALVE IN MANHOLE ON SHOULDER
NOT TO SCALE

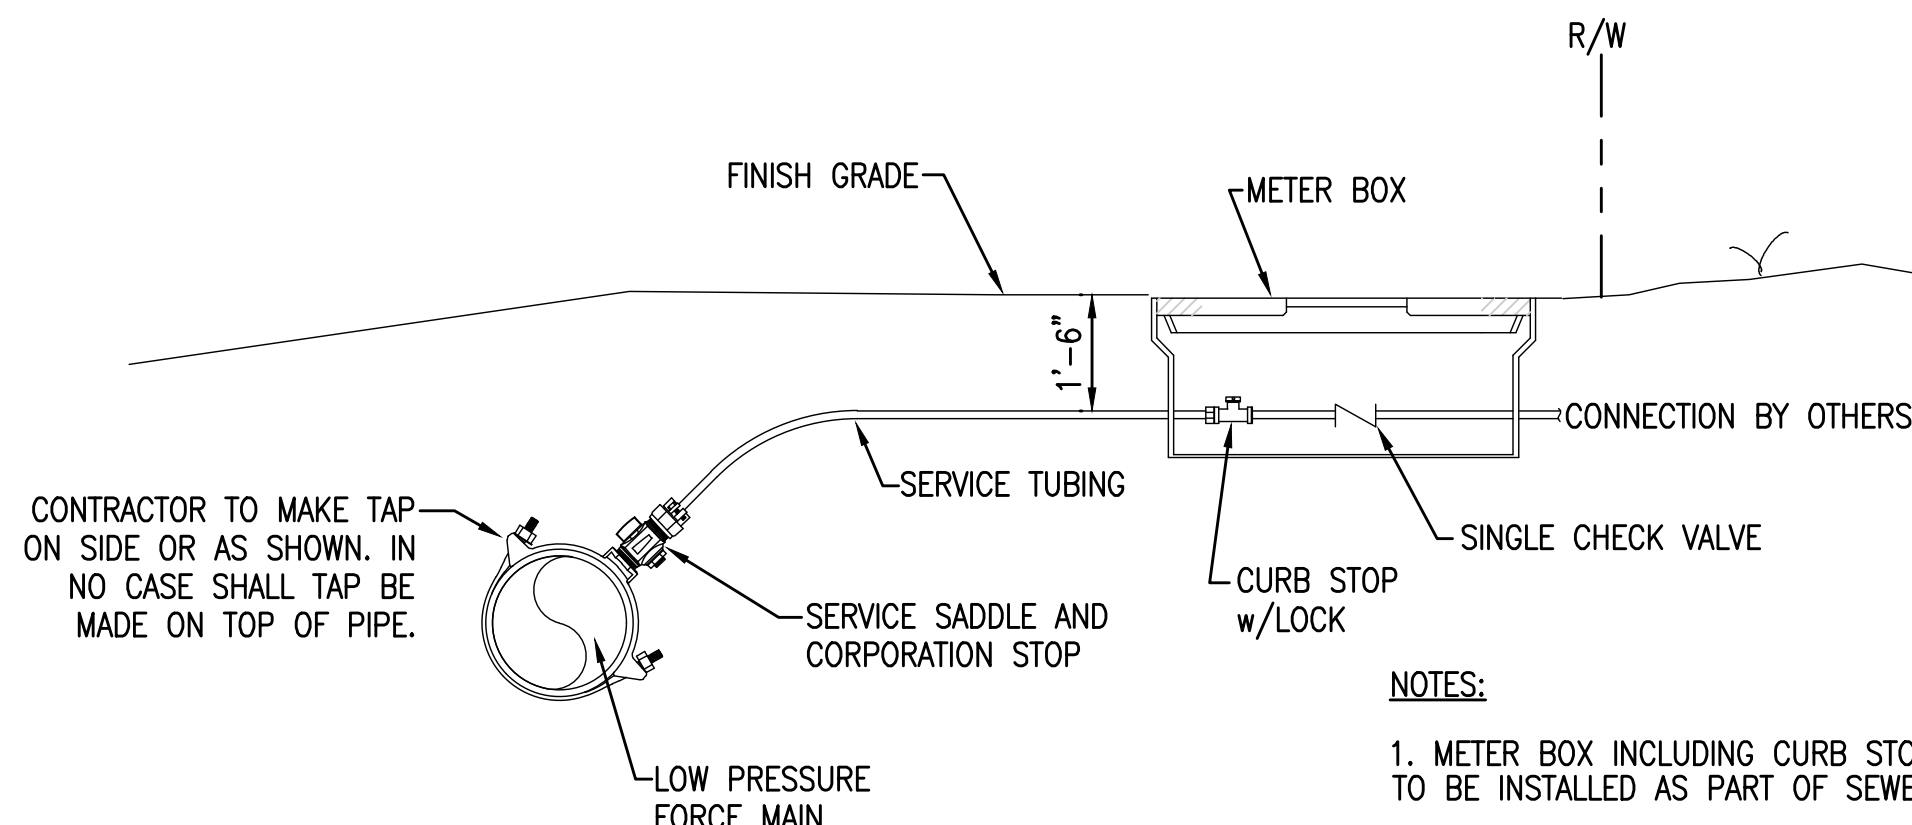


A2 TYPICAL SERVICE CONNECTION - SHORT
NOT TO SCALE

NOTES:

1. METER BOX INCLUDING CURB STOP WITH LOCK TO BE INSTALLED AS PART OF SEWER FM CONTRACT.

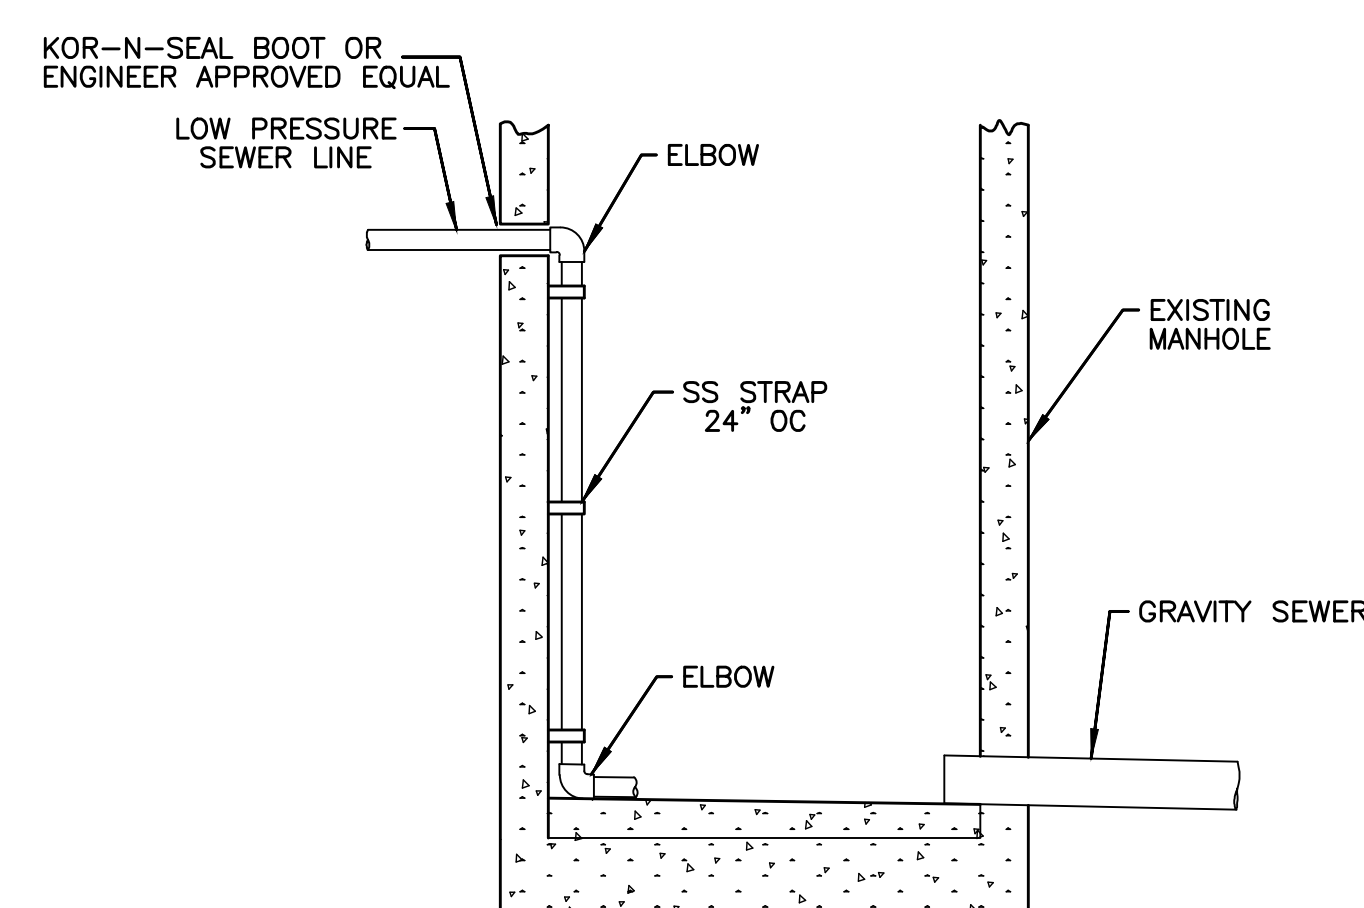


D5 TYPICAL DROP CONNECTION LPSS IN EXISTING MANHOLE
NOT TO SCALE

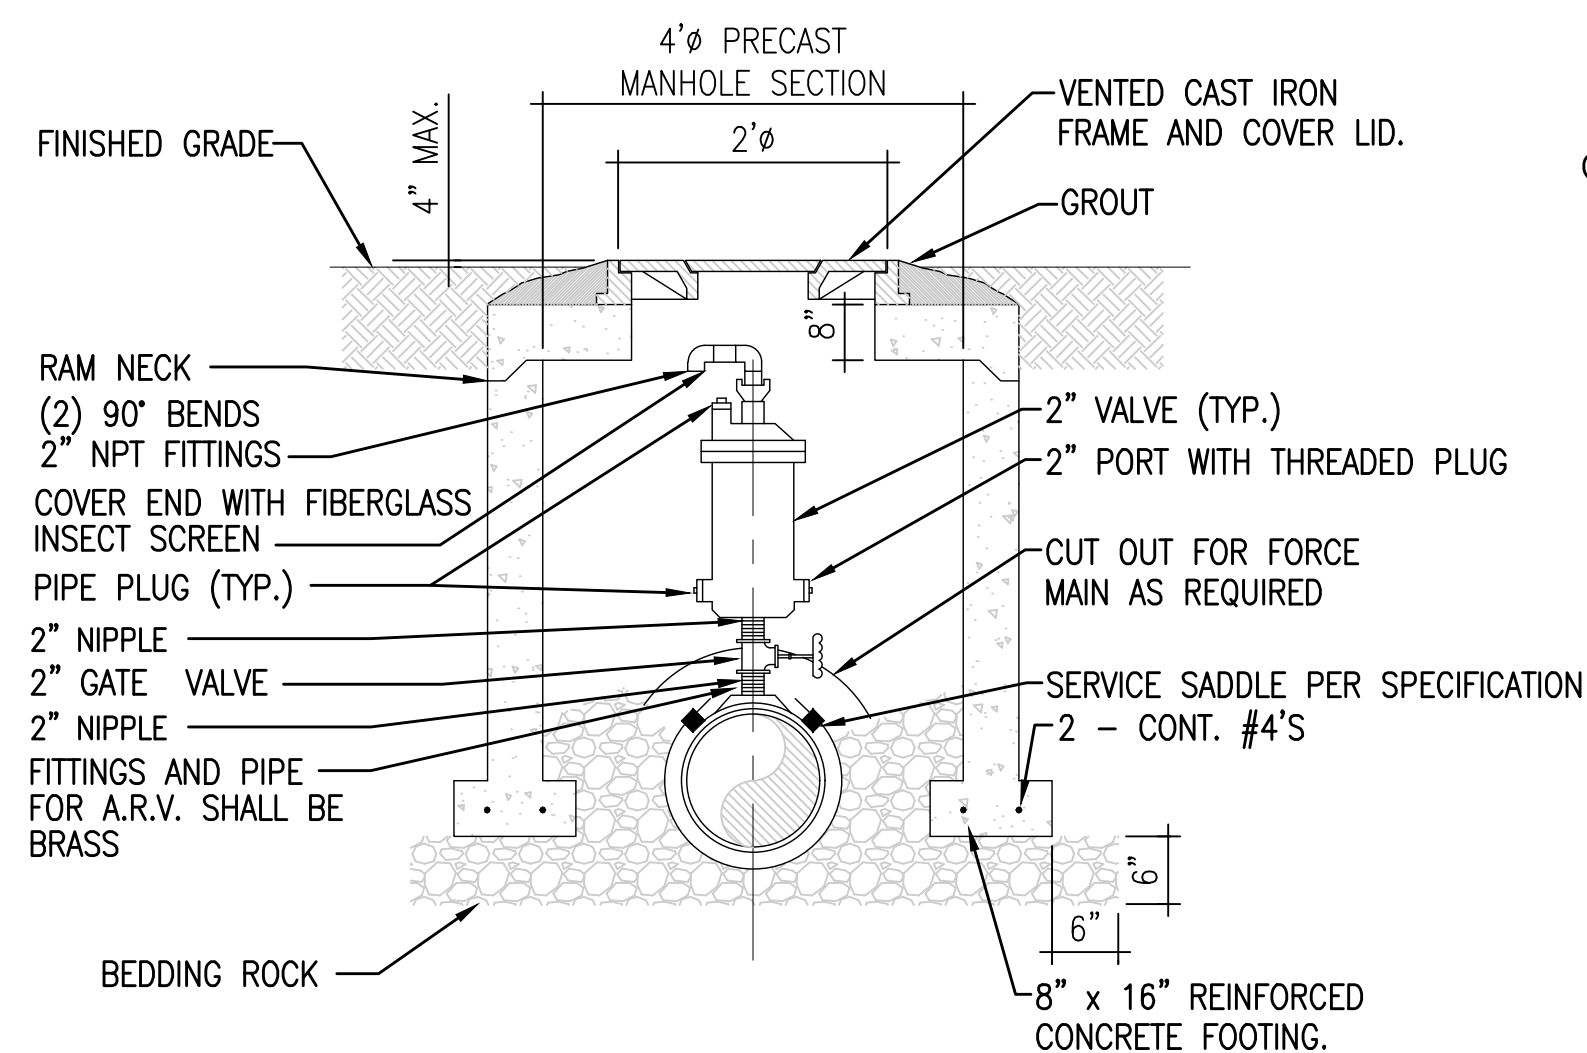

NOTE:
FOR PIPELINES SMALLER THAN 6", USE UNISTRUT DRIVEN 3' INTO GROUND FOR SUPPORT.

B5 AIR/VACUUM RELEASE VALVE IN MANHOLE ON SHOULDER
NOT TO SCALE

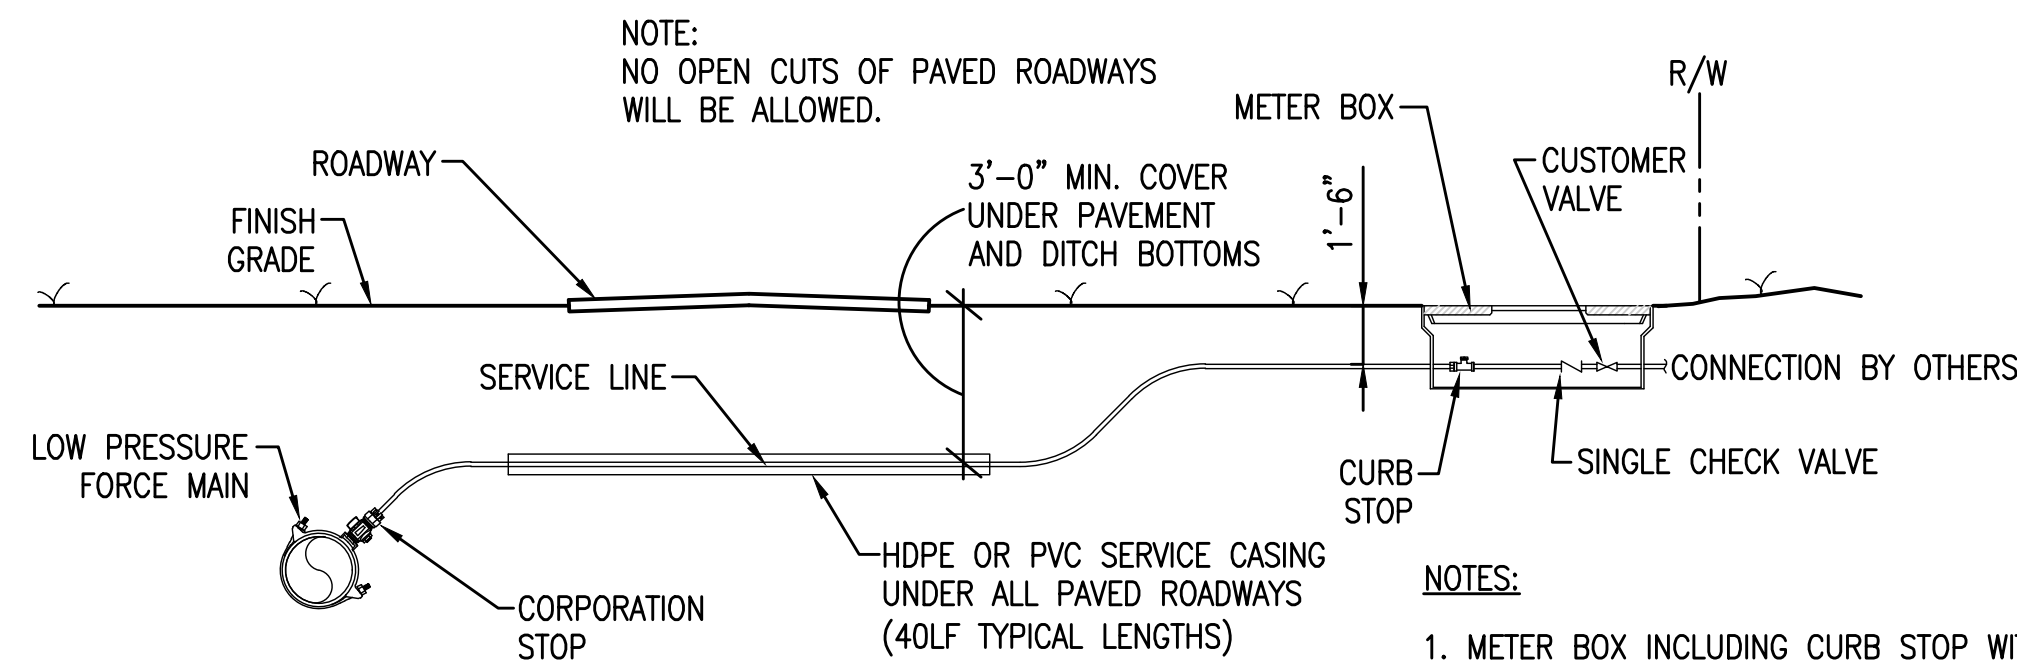


A4 TYPICAL SERVICE CONNECTION - LONG
NOT TO SCALE

NOTES:

1. METER BOX INCLUDING CURB STOP WITH LOCK TO BE INSTALLED AS PART OF SEWER FM CONTRACT.

NO.	DATE	APPR.	REVISION/ACTION TAKEN
1	02/22	JEA	RELEASED FOR BID
DESIGNED BY:	KG		
DRAWN BY:	THO		
CHK'D BY:	JEA		
PROJ. MGR:	RWD		
DATE:	FEBRUARY 2022		

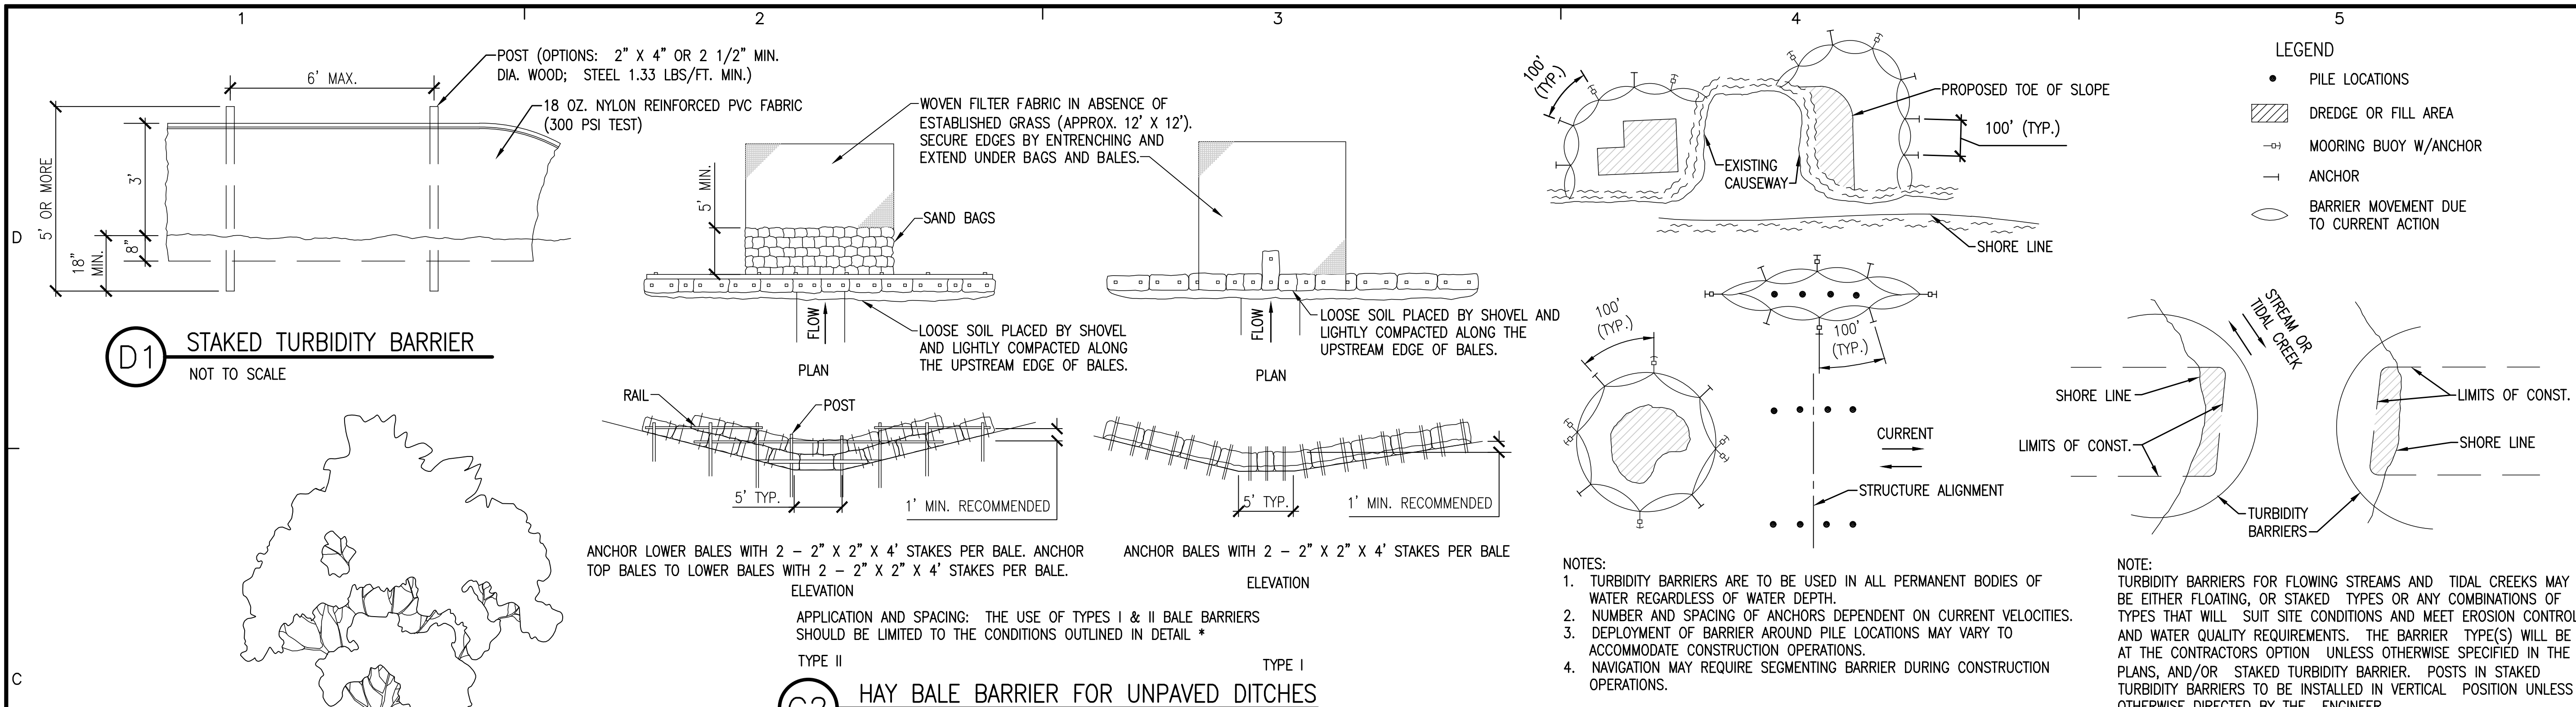

STAKED TURBIDITY BARRIER
NOT TO SCALE

C2 HAY BALE BARRIER FOR UNPAVED DITCHES
NOT TO SCALE

C4 TURBIDITY BARRIER APPLICATIONS
NOT TO SCALE

C1 TREE PROTECTION DETAIL
NOT TO SCALE


A2 HAY BALE BARRIERS FOR FILL SLOPES
NOT TO SCALE

A4 TYPE III SILT FENCE APPLICATIONS
NOT TO SCALE

A1 EROSION CONTROL BARRIER
AND FENCE SPACING GUIDE
NOT TO SCALE

C-903 STANDARD DETAILS	PROJECT NO: 204110.46				NO.	DATE	APPR.	REVISION / ACTION TAKEN	SSRUS SOUNDSIDE SEPTIC TANK ELIMINATION PROGRAM PHASE B SANTA ROSA COUNTY, FLORIDA	BASKERVILLE-DONOVAN, INC. Innovative Infrastructure Solutions 448 W. MAIN ST. - PENSACOLA, FL 32502 (850)438-9861 ENGINEERING BUSINESS: EB-0000340 Pensacola - Panama City Beach - Tallahassee - Mobile JAMES E. ANDERSON, P.E. FL. REG. ENGINEER #67494 This drawing is the property of BASKERVILLE-DONOVAN, INC. and is not to be reproduced in whole or in part. It is not to be used on any other project and is to be returned upon request.
	DESIGNED BY: KG				1	02/22	JEA	RELEASED FOR BID		
	DRAWN BY: THO									
	CHK'D BY: JEA									
	PROJ. MGR: RWD									
	DATE: FEBRUARY 2022				NOT RELEASED FOR CONSTRUCTION BY	DATE				

K:\204 Gulf Breeze and SSRUS\20410.46 Soundside STEP\DWG\C-904.dwg, Feb 14, 2022 - 4:41:00PM, toverton

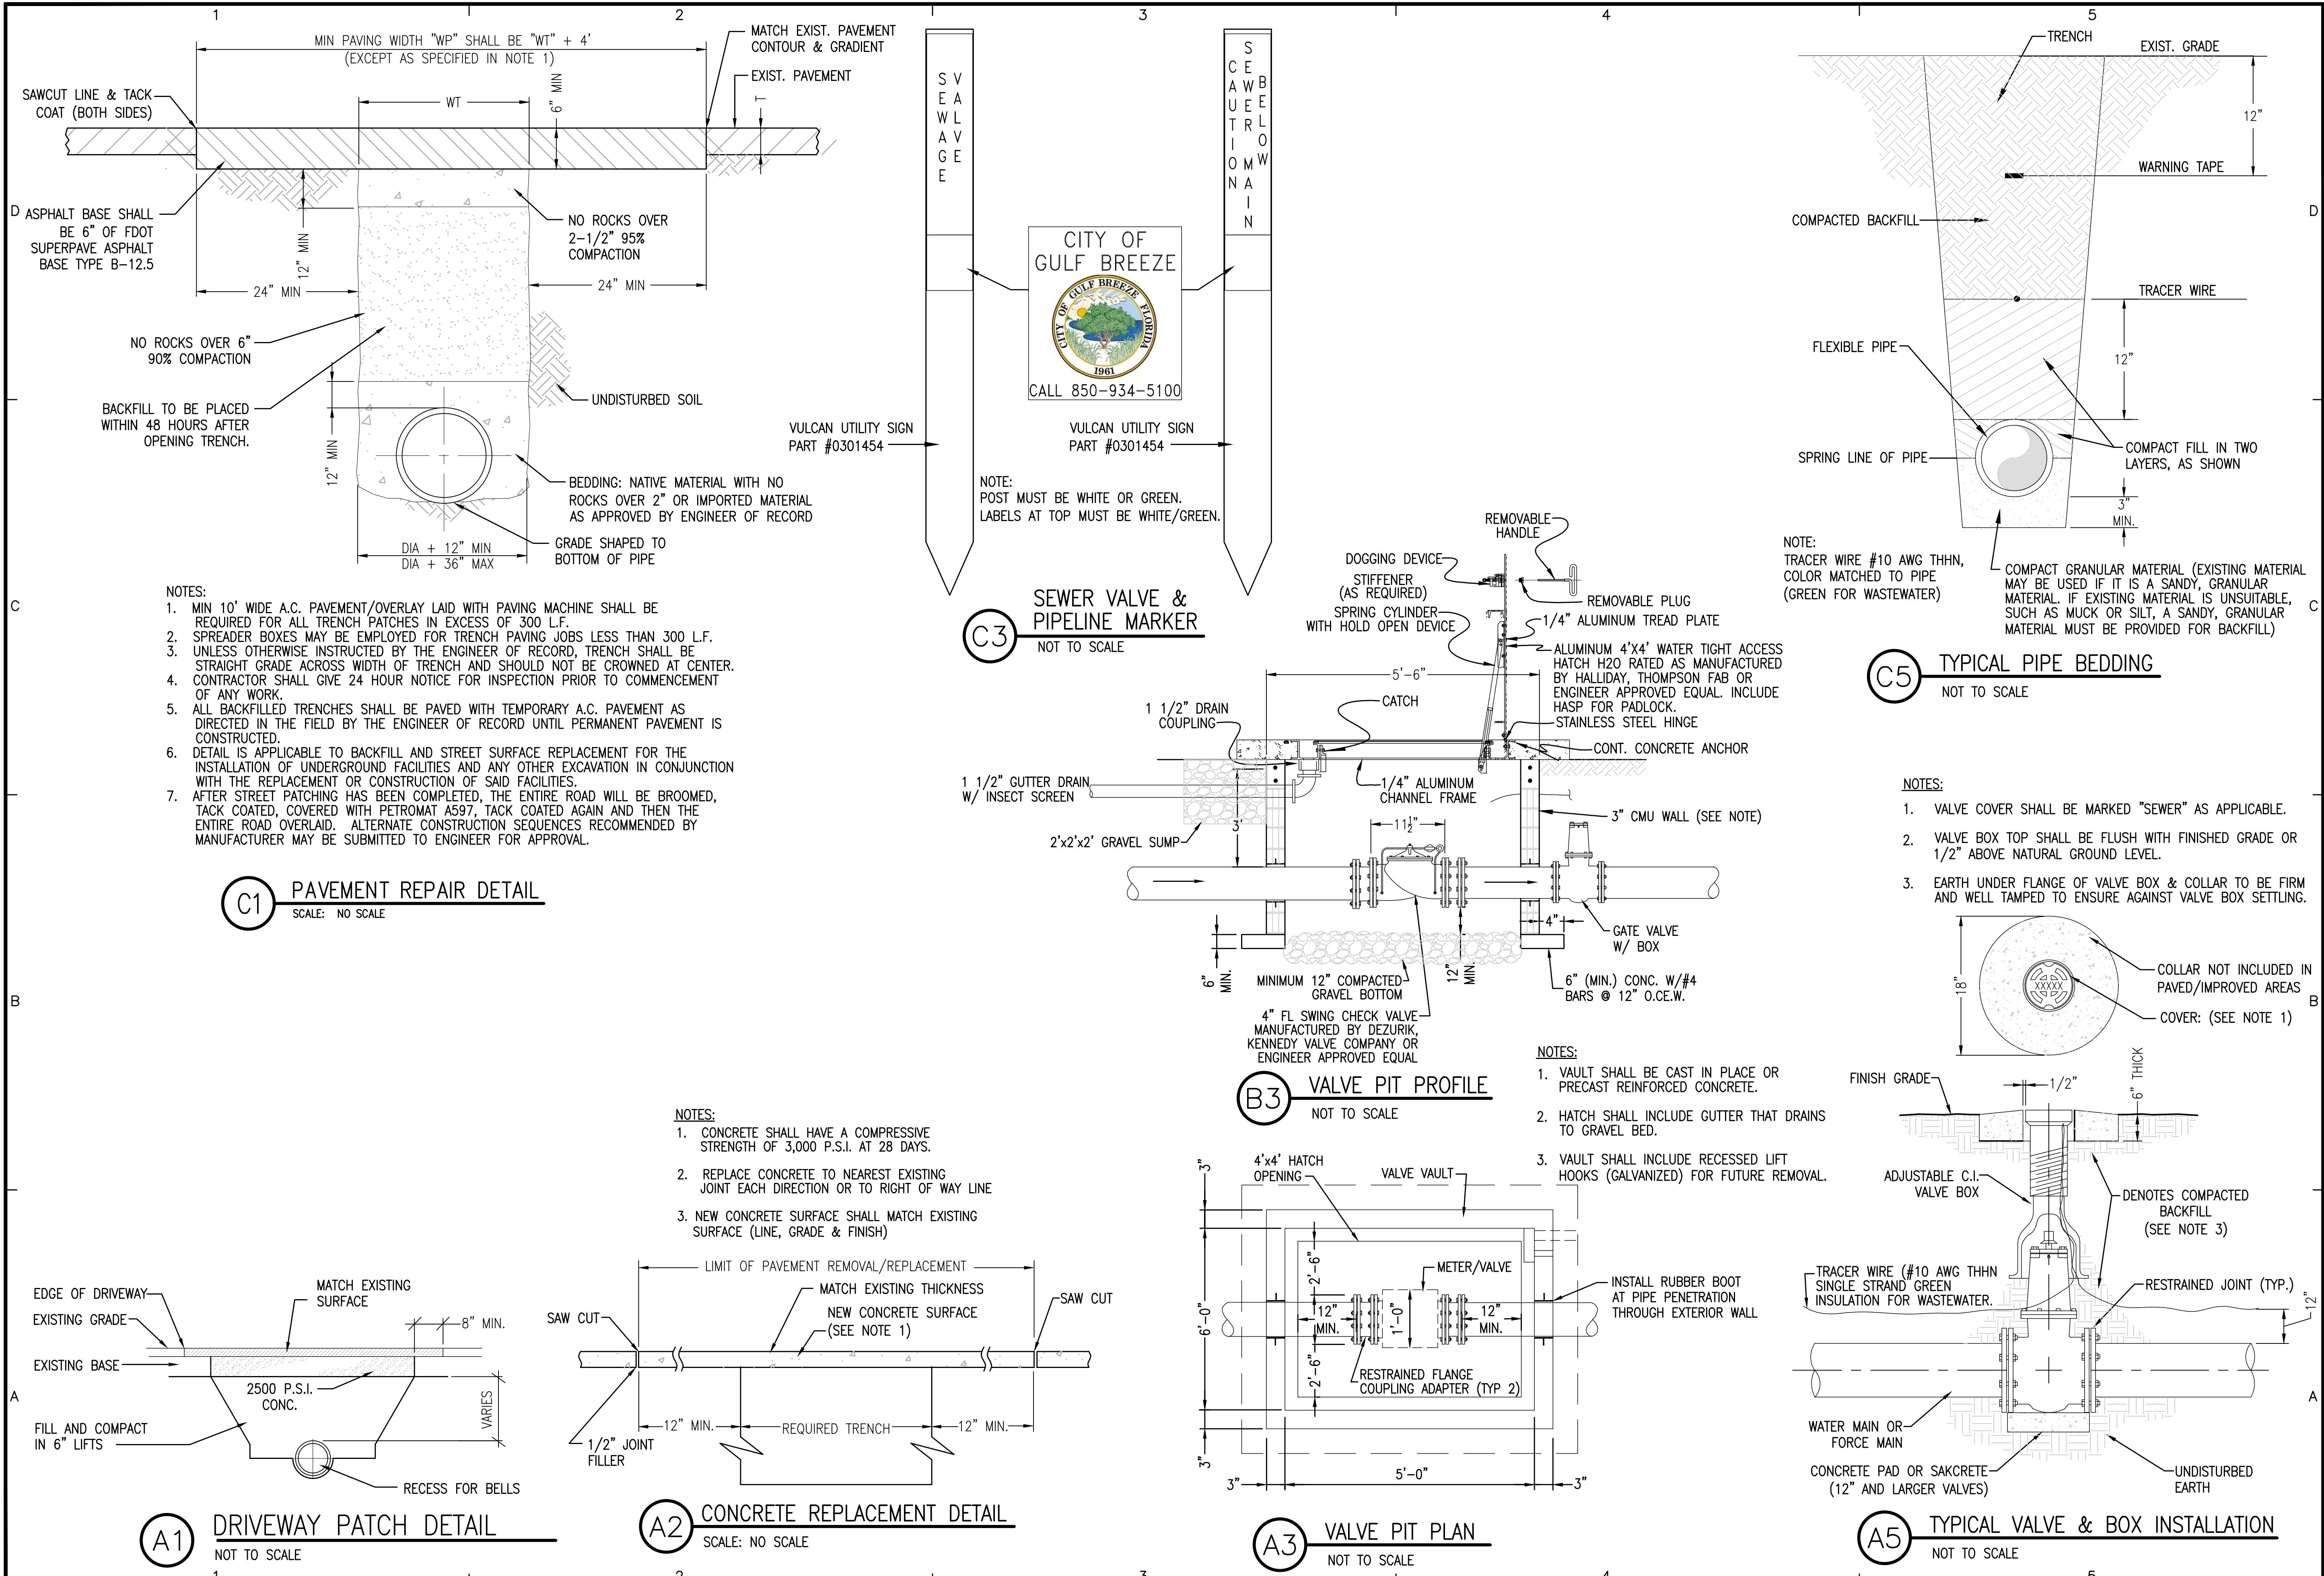

BASKERVILLE-DONOVAN, INC.
Innovative Infrastructure Solutions
449 W MAIN ST. PENSACOLA, FL 32502 (850)438-9861
Pensacola - Panama City Beach - Tallahassee - Mobile
ENGINEERING BUSINESS EB0000340
This drawing is the property of BASKERVILLE-DONOVAN, INC. and is not to be reproduced in whole or in part. It is not to be used on any other project and is to be returned upon request.

JAMES E. ANDERSON, P.E.
FL REG. ENGINEER #67494


SSRUS SOUNDSIDE
SEPTIC TANK
ELIMINATION PROGRAM
PHASE B

SANTA ROSA COUNTY, FLORIDA

PROJECT NO:	20410.46	DESIGNED BY:	KG	DRAWN BY:	THO	CHK'D BY:	JEA	PROJ. MGR:	RWD	DATE:	FEBRUARY 2022
NO.	1	DATE	02/22	APPR.	JEA	RELEASED FOR BID		NOT RELEASED FOR CONSTRUCTION BY		DATE	
REVISION / ACTION TAKEN											

STANDARD
DETAILS

C-904

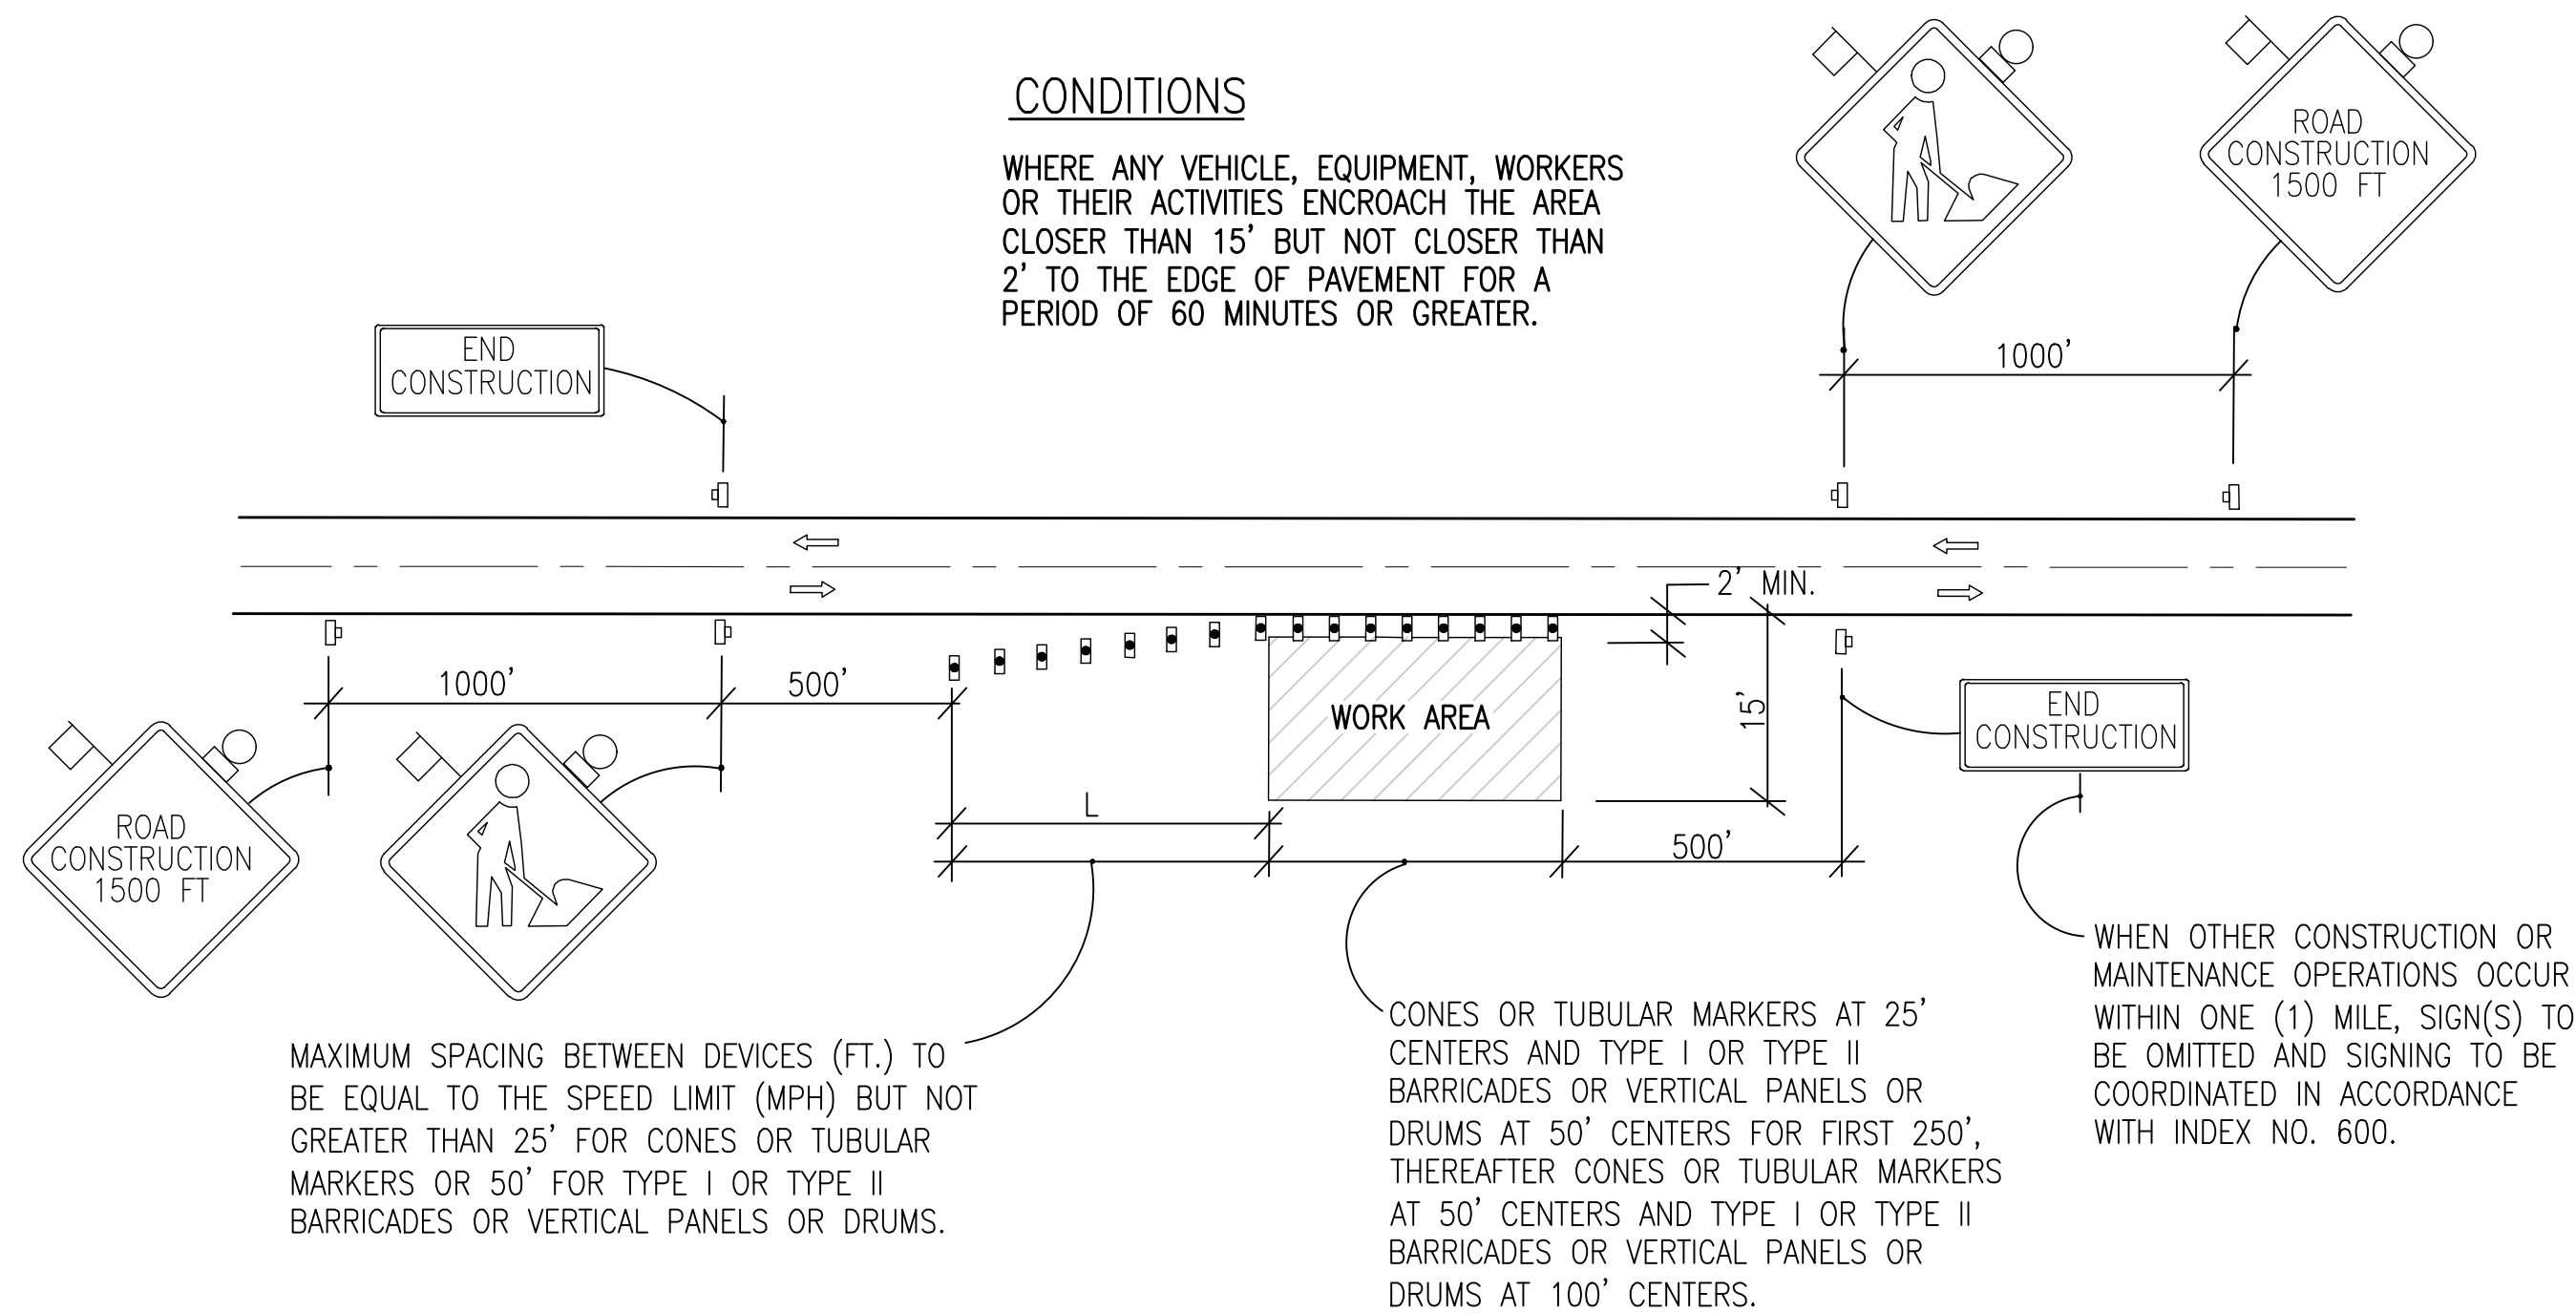

C1

NOT TO SCALE

SYMBOLS

-

GENERAL NOTES

1. IF THE WORK OPERATION (EXCLUDING ESTABLISHING AND TERMINATING THE WORK AREA) REQUIRES THAT TWO OR MORE WORK VEHICLES CROSS THE OFFSET ZONE IN ANY ONE HOUR, TRAFFIC CONTROL WILL BE IN CONFORMANCE WITH INDEX NO. 602.
2. NO SPECIAL SIGNING IS REQUIRED.
3. WHEN A SIDE ROAD INTERSECTS THE HIGHWAY WITHIN THE WORK AREA ADDITIONAL TTC DEVICES SHALL BE PLACED IN ACCORDANCE WITH OTHER APPLICABLE TCZ INDEXES.
4. WHEN CONSTRUCTION ACTIVITIES ENCROACH ON A SIDEWALK REFER TO INDEX NO. 660.
5. FOR GENERAL TCZ REQUIREMENTS AND ADDITIONAL INFORMATION REFER TO INDEX NO. 600.

GENERAL LANE CLOSURE NOTES

1. WORK OPERATIONS SHALL BE CONFINED TO ONE TRAFFIC LANE LEAVING THE ADJACENT LANE OPEN TO TRAFFIC.
2. ALL VEHICLES, EQUIPMENT, WORKERS AND THEIR ACTIVITIES ARE RESTRICTED AT ALL TIMES TO ONE SIDE OF THE PAVEMENT.
3. ALL SIGNS SHALL BE POST MOUNTED IF THE CLOSURE TIME EXCEEDS 12 HOURS.
4. WHEN WORK IS BEING PERFORMED ON A MULTILANE UNDIVIDED ROADWAY THE SIGNS NORMALLY MOUNTED IN THE MEDIAN (AS SHOWN) SHALL BE OMITTED.

SYMBOLS

- | | |
|--|---|
| | WORK AREA |
| | SIGN WITH 18" X 18" (MIN.) ORANGE FLAG AND TYPE B LIGHT |
| | TYPE I OR TYPE II BARRICADE OR VERTICAL PANEL OR DRUM (W/ STEADY BURNING LIGHT AT NIGHT ONLY). CONES OR TUBULAR MARKERS MAY BE USED DURING DAYLIGHT ONLY. |
| | WORK ZONE SIGN |

C4

NOT TO SCALE

GENERAL NOTES

1. ALL VEHICLES, EQUIPMENT, WORKERS (EXCEPT FLAGGERS) AND THEIR ACTIVITIES ARE RESTRICTED AT ALL TIMES TO ONE SIDE OF THE ROADWAY.
2. IF THE WORK OPERATION DOES NOT EXCEED 60 MINUTES, TRAFFIC CONTROL WILL BE IN CONFORMANCE WITH INDEX NO. 607.
3. IF THE WORK OPERATION ENCLOSES ON THE THROUGH TRAFFIC LANES OR WHEN FOUR OR MORE WORK VEHICLES ENTER THE THROUGH TRAFFIC LANES IN A ONE HOUR PERIOD A FLAGGER SHALL BE PROVIDED AND A FLAGGER SIGN SHALL BE SUBSTITUTED FOR THE WORKERS SIGN. THE FLAGGER SHALL BE POSITIONED AT THE POINT OF VEHICLE ENTRY OR DEPARTURE FROM THE WORK AREA.
4. THE FIRST TWO WARNING SIGNS, EACH SIDE, SHALL HAVE A 18" X 18" (MIN.) ORANGE FLAG AND A TYPE B LIGHT ATTACHED AND OPERATING AT ALL TIMES. MESH SIGNS MAY BE USED FOR (DAYLIGHT ONLY) OPERATIONS. TYPE B LIGHTS AND ORANGE FLAGS ARE NOT REQUIRED.
5. THE WORKERS LEGEND SIGN MAY BE SUBSTITUTED FOR THE SYMBOL SIGN.
6. ALL SIGNS SHALL BE POST MOUNTED IF THE CLOSURE EXCEEDS 12 HOURS.
7. $L \text{ (MIN)} = \frac{WS}{2}$ FOR SPEEDS $\geq 45 \text{ MPH}$
 $= \frac{WS^2}{120}$ FOR SPEEDS $\leq 40 \text{ MPH}$
WHERE:
W= WIDTH OF LATERAL TRANSITION IN FEET
S= POSTED SPEED LIMIT (MPH).
8. ARROWS DENOTE DIRECTION OF TRAFFIC ONLY AND DO NOT REFLECT PAVEMENT MARKINGS.
9. LONGITUDINAL DIMENSIONS ARE TO BE ADJUSTED TO FIT FIELD CONDITIONS. SEE FDOT INDEX NO. 600.
10. WORKERS SIGNS TO BE REMOVED OR FULLY COVERED WHEN NO WORK IS BEING PERFORMED.
11. END CONSTRUCTION SIGNS REQUIRED ONLY WHEN WORK EXCEEDS ONE DAYLIGHT PERIOD.
12. WHEN A SIDE ROAD INTERSECTS THE HIGHWAY ON WHICH WORK IS BEING PERFORMED ADDITIONAL TRAFFIC CONTROL DEVICES SHALL BE ERECTED IN ACCORDANCE WITH OTHER APPLICABLE TCZ INDEXES.
13. FOR GENERAL TCZ REQUIREMENTS AND ADDITIONAL INFORMATION, REFER TO FDOT INDEX 600.